


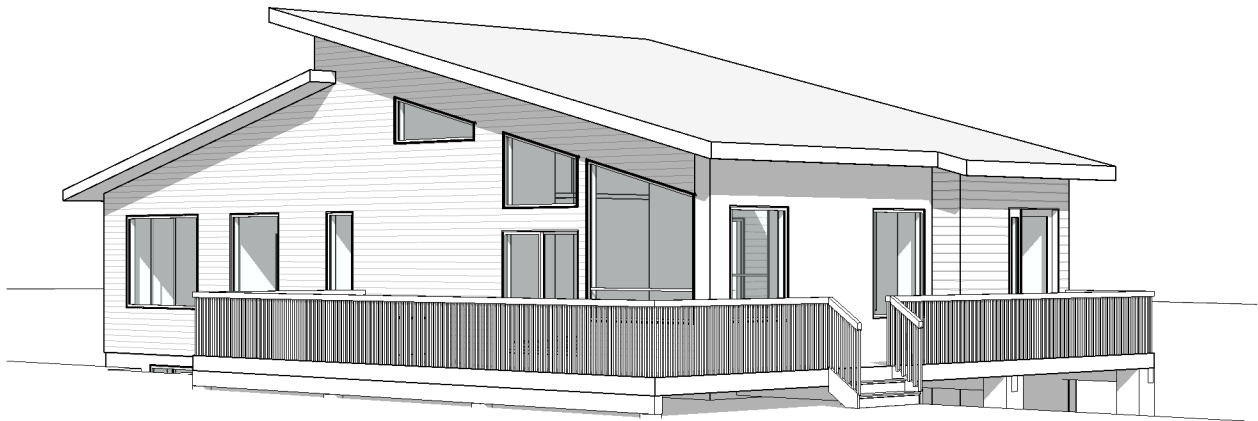

ABEL & CHRISTINE RESIDENCE



easy to read house plans
LikeHomeDesign.com Inc.
780.757.6543
stock plans - custom house - multi-unit
additions - commercial - industrial

LIKEHOMEDESIGN.COM INC. ASSUMES NO LIABILITY FOR ERRORS OR OMISSIONS THAT MAY AFFECT CONSTRUCTION. IT IS THE RESPONSIBILITY OF THE GENERAL CONTRACTOR / BUILDER TO CHECK AND VERIFY ALL SIZES, DIMENSIONS AND CONSTRUCTION DETAILS PRIOR TO ANY CONSTRUCTION. ALL DISCREPANCIES TO BE REPORTED TO LIKEHOMEDESIGN.COM INC. FOR CLARIFICATION PRIOR TO CONSTRUCTION. DO NOT SCALE DRAWINGS. VARIATIONS AND MODIFICATIONS TO WORK SHOWN ON THESE DRAWINGS SHALL NOT BE CARRIED OUT WITHOUT WRITTEN PERMISSION FROM LIKEHOMEDESIGN.COM INC.

LIKEHOMEDESIGN.COM INC. WAIVES ALL RESPONSIBILITY REGARDING ANY STRUCTURAL ENGINEERING AND ONSITE CONDITIONS SUCH AS SOIL BEARING CAPACITY, DEPTH OF FROST LINE, WATER TABLES. ALL ENGINEERING AND ENGINEERS STAMP TO BE THE SOLE RESPONSIBILITY OF BUILDER AND/OR OWNER. THESE PLANS, DESIGNS, AND DETAILS ARE THE PROPERTY OF LIKEHOMEDESIGN.COM INC. AND MAY NOT BE REPRODUCED OR USED BY ANYONE, EITHER IN TOTAL OR IN PART, WITHOUT WRITTEN CONSENT FROM LIKEHOMEDESIGN.COM INC.

CLIENT/BUILDER
BUILDER PROJECT #
BUILDER PROJECT NAME:

ADDRESS
LEGAL

ABEL & CHRISTINE RESIDENCE

PROJECT # 855
STATUS ISSUED FOR PERMITS
DATE MARCH 28, 2022
DRAWN BY OP
CHECKED BY IT
SCALE

TITLE SHEET

A1

SHEET LIST

A1	TITLE SHEET
A2	GENERAL INFO
A3	FOUNDATION WALL
A4	BASEMENT PLAN
A5	MAIN FLOOR PLAN
A6	FRONT ELEVATION
A7	LEFT ELEVATION
A8	RIGHT ELEVATION
A9	REAR ELEVATION

SHEET LIST

A10	SECTION 1
A11	SECTIONS 2 & 3
A12	DETAILED SECTIONS
A13	DETAILED SECTIONS
A14	DETAILED SECTIONS
A15	DETAILED RSI SECTIONS
A16	WINDOW DETAILS
A17	WINDOW & DOOR DETAILS

GENERAL NOTES

1. INFORMATION REGARDING THE SITE HAS BEEN OBTAINED FROM THE OWNER. THE DESIGNER IS NOT RESPONSIBLE FOR THE ACCURACY OF ANY ASSUMPTIONS REGARDING GRADE OR BEARING.
2. THESE DRAWINGS SHALL NOT BE SCALED. ANY ERRORS OR DISCREPANCIES SHALL BE BROUGHT TO THE ATTENTION OF THE DESIGNER.
3. THE CONTRACTOR SHALL ENGAGE THE SERVICES OF A LAND SURVEYOR FOR THE PURPOSE OF LOCATING THE PROPOSED BUILDING ON SITE AND ESTABLISHING ALL ELEVATIONS.
4. ALL CONSTRUCTION SHALL BE IN ACCORDANCE WITH THE CURRENT LOCAL BUILDING CODE.
5. ALL UTILITIES, CONNECTIONS AND HOOKUPS SHALL CONFORM WITH ALL RELEVANT REGULATIONS.
6. THE GENERAL CONTRACTOR IS RESPONSIBLE FOR OBTAINING ALL NECESSARY CONSTRUCTION PERMITS.
7. ALL CONTRACTORS SHALL BE CURRENT WITH ALL THE REQUIREMENTS OF THE WORKMAN'S COMPENSATION BOARD AND THEIR ACCOUNTS.
8. THE OWNER IS RESPONSIBLE FOR OBTAINING ANY STRUCTURAL, MECHANICAL, OR ELECTRICAL ENGINEERING AS MAY BE REQUIRED TO COMPLETE THE PROJECT.
9. THE OWNER IS RESPONSIBLE FOR THE SELECTION OF ALL INTERIOR DESIGN ELEMENTS.
10. THE OWNER IS RESPONSIBLE FOR PROVIDING A GEOTECHNICAL REPORT ON SOIL CONDITIONS AT THE SITE. ASSUMPTIONS WILL BE MADE OTHERWISE.
11. THE OWNER SHALL ANSWER ANY QUESTIONS ARISING FROM THE TENDERING OF THIS PROJECT.

12. PRIOR TO UNDERTAKING THE WORK, ALL CONTRACTORS SHALL FAMILIARIZE THEMSELVES WITH THE SCOPE OF THE WORK.

13. ALL CONTRACTORS ON THE PROJECT SHALL BE DULY LICENSED BY REGULATORY AUTHORITIES TO PERFORM THEIR TASK UNDERTAKEN.

14. ALL CONTRACTORS WORKING ON THE SITE SHALL CARRY LIABILITY INSURANCE ACCEPTABLE TO THE OWNER.

15. ALL PERTINENT LABOUR LAWS AND SAFETY STANDARDS SHALL BE STRICTLY ADHERED TO.

16. ALL MANUFACTURED FLOOR AND ROOF STRUCTURAL MEMBERS SHALL BE ENGINEERED WITH SHOP DRAWINGS PREPARED FOR OWNERS APPROVAL.

17. ABSOLUTELY NO CONSTRUCTION SHALL START PRIOR TO ISSUANCE OF RELEVANT PERMITS.

ABC 9.36 NOTES

1. USE HVAC COMPONENTS AND EQUIPMENT WITH MINIMUM PERFORMANCE AS PER ABC 9.36
2. USE HRV UNIT IN THIS BUILDING CONFORMING TO CAN/CSA-C439
3. USE SERVICE WATER HEATING COMPONENTS AND EQUIPMENT WITH MINIMUM PERFORMANCE AS PER ABC 9.36
4. DISCHARGE DUCT TO HAVE MOTORIZED DAMPER, OR GRAVITY/SPRING-OPERATED BAKCFLOW DAMPER INSTALLED.
5. INTAKE DUCT TO HAVE "FAIL-OPEN" MOTORIZED DAMPER, EXCEPT WHERE DISALLOWED BY OTHER REGULATION OR WHERE SYSTEM OPERATES CONTINUOUSLY.
6. MINIMUM 12mm THICK PIPE INSULATION TO BE INSTALLED FOR MINIMUM FIRST 2 m OF PIPING FROM INLET AND OUTLET OF WATER HEATER.
7. ALL EXTERIOR WINDOWS AND DOORS TO MEET A MAXIMUM U-VALUE OF 1.60. SINGLE EXTERIOR DOOR IS ALLOWED TO HAVE A MAXIMUM U-VALUE OF 2.60.
8. IF INDICATED ON PLANS, THE MAXIMUM AREA OF GLASS BLOCKS TO BE 1.85 sq.m. WITH MAXIMUM U-VALUE OF 2.90
9. IF INDICATED ON PLANS, THE SKYLIGHTS TO HAVE A MAXIMUM U-VALUE OF 2.70.
10. ATTIC/ACCESS HATCHES TO HAVE MINIMUM RSI OF 2.6
11. GARAGE OVERHEAD DOORS TO HAVE MINIMUM RSI OF 1.1

CONSTRUCTION NOTES

- SITE

1. GRADE LINE IS SUGGESTED ONLY. ACTUAL GRADE LINE AND NUMBER OF EXTERIOR STEPS NEEDED MUST BE VERIFIED ON SITE.
2. GRADE AROUND THE BUILDING SHALL BE GRADED TO PREVENT DRAINAGE TOWARD FOUNDATION.
- FOUNDATION

3. IT IS THE RESPONSIBILITY OF THE BUILDER/OWNER TO ENSURE THE DESIGN AND CONSTRUCTION OF THE FOUNDATION AND FOOTINGS MEET THE REQUIREMENTS OF THE LOCAL BUILDING AUTHORITY.
4. ALL FOUNDATIONS TO BE CONSTRUCTED TO MEET THE REQUIREMENTS OF THE LATEST MUNICIPAL, CITY, PROVINCIAL, STATE AND NATIONAL BUILDING CODES AND/OR AUTHORITY HAVING JURISDICTION.
5. IT IS POSSIBLE THAT LOCAL AUTHORITIES MAY REQUIRE AN ENGINEER'S REPORT TO CONFIRM THIS DESIGN. IF SUCH A REPORT IS REQUIRED, IT IS THE RESPONSIBILITY OF THE BUILDER/OWNER TO PROVIDE THE REPORT.
6. ALL FOOTINGS AND GRADE BEAMS SHALL BE POURED ON UNDISTURBED SOIL ONLY.
7. CONCRETE PADS FOR ADJUSTABLE STEEL TELEPOSTS TO BE DESIGNED AS PER FLOOR JOIST ENG. SPECS.

STRUCTURE
8. ENGINEERED MATERIAL INCLUDING: ROOF TRUSSES, FLOOR JOISTS, ENGINEERED BEAMS AND TELEPOSTS LOADS TO BE PROVIDED BY THE SUPPLIER OF THE MATERIAL TO THE BUILDER PRIOR TO COMMENCEMENT OF CONSTRUCTION.

9. ALL POSTS TO BE MINIMUM 4-2x4 OR 4-2x6, UNLESS NOTED OTHERWISE.

10. PROVIDE DOUBLE JOISTS UNDER ALL PARALLEL PARTITIONS. PROVIDE DOUBLE FRAMING AROUND ALL OPENINGS.

OTHER
11. PROVIDE INSULATED AND WEATHERSTRIPPED ATTIC ACCESS HATCH AS PER LOCAL BUILDING CODE WITH A MINIMUM 22"x28" OPENING.

13. LEAVE AN AIR SPACE BETWEEN SUBFLOOR AND INSULATION IN CANTILEVERS FOR WARM AIR CIRCULATION.

14. PROVIDE SMOKE AND CO2 ALARMS, INSTALLED USING PERMANENT ELECTRICAL CONNECTIONS AS PER LATEST CODES.

15. PROVIDE ROOF VENTS AS REQUIRED BY LOCAL BUILDING CODE.

16. ALL WINDOW WELLS TO BE TIED TO PERFORATED PIPE WITH A STANDPIPE.

17. METAL FLASHING MUST BE PROVIDED AT ALL DOORS AND WINDOWS, AND AT ALL ROOF/WALL CONNECTIONS.

18. PROVIDE A MINIMUM OF 2" CLEARANCE BETWEEN WOODEN ELEMENTS AND FLUES.

19. FLASH ALL ROOF VALLEYS AND ROOF PENETRATIONS.

20. PROVIDE MINIMUM 6" CLEARANCE FROM GRADE TO WOOD CONSTRUCTION. AT ALL AREAS WHERE DIFFERENCE BETWEEN GRADE AND LUMBER IS LESS THAN 6", PROVIDE PRESSURE TREATED LUMBER OF BITUTHANE MEMBRANE TO 8" ABOVE GRADE.

21. FRAMER TO VERIFY LOCATION OF WINDOW OVER KITCHEN SINK WITH THE BUILDER PRIOR TO FRAMING.

22. FRAMER TO VERIFY THE SIZE OF THE FIRE PLACE AND THE SIZE OF THE PLUMBING FIXTURES WITH THE BUILDER PRIOR TO FRAMING.

DRAFTING NOTES

1. ALL INTERIOR DIMENSIONS ON THE PLANS ARE TO THE STUD WALL. ALL DIMENSIONS TO THE EXTERIOR SIDE OF EXTERIOR WALL ARE TO THE EXTERIOR SIDE OF THE SHEATHING.
2. ALL WINDOWS SIZES INDICATED ARE APPROXIMATE R.O. SIZE, UNLESS NOTES OTHERWISE. WINDOW SIZES, STYLES, AND TYPES MUST BE VERIFIED WITH OWNER PRIOR TO ORDERING OR INSTALLATION.

COPYRIGHT

1. LIKEHOMEDESIGN.COM INC. RETAINS COPYRIGHT OF THESE DRAWINGS, AND GRANTS NON TRANSFERABLE RIGHT TO BUILD ONE BUILDING USING THESE DRAWINGS ON THE PROPERTY INDICATED.
2. IF ANYONE DESIRES TO BUILD FROM THESE DRAWINGS AGAIN, ONE MUST CONTACT LIKEHOMEDESIGN.COM INC. IN ORDER TO PURCHASE A LICENCE TO DO SO.

WALL LEGEND:

- TYPICAL EXTERIOR BASEMENT WALL:**
8" CONCRETE WALL, SEE DETAILED SECTIONS
- TYPICAL EXTERIOR WALL:**
EXTERIOR FINISH (SEE ELEVATIONS),
SEE DETAILED SECTIONS
- TYPICAL INTERIOR 2x6 WALL:**
1/2" GYPSUM BOARD, 2x6 STUDS @ 16" O.C.,
1/2" GYPSUM BOARD
- TYPICAL INTERIOR 2x4 WALL:**
1/2" GYPSUM BOARD, 2x4 STUDS @ 16" O.C.,
1/2" GYPSUM BOARD
- TYPICAL INTERIOR 2x6 PLUMBING WALL:**
1/2" GYPSUM BOARD, 2x6 STUDS @ 16" O.C.,
1/2" GYPSUM BOARD

JOISTS LEGEND

- A

11 7/8" TJI JOISTS @ 16" O.C.
- B



2x8 P.T. JOISTS @ 16" O.C.
- R

PREENGINEERED ROOF TRUSSES @ 24" O.C.

LEGEND

- EXHAUST FAN
- SMOKE / CO DETECTOR

⏏ = ⏏ = ⏏ = ⏏ = ⏏ = ⏏ = ⏏ =

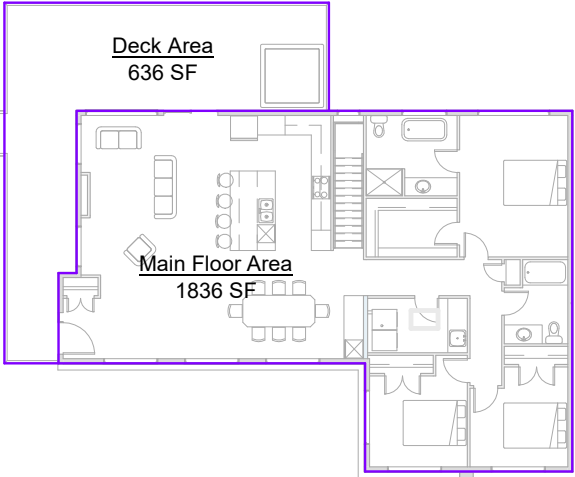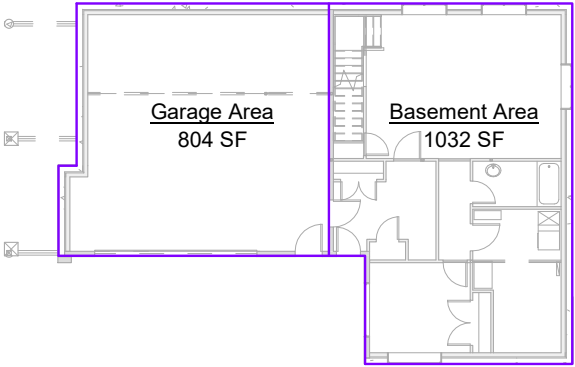

Area Schedule (Building)	
Name	Area

Main Floor Area	1836 SF
Garage Area	804 SF
Deck Area	636 SF
Basement Area	1032 SF
4308 SF	



easy to read house plans

LikeHomeDesign.com Inc.

780.757.6543

stock plans - custom house - multi-unit
additions - commercial - industrial

LIKEHOMEDESIGN.COM INC. ASSUMES NO LIABILITY FOR ERRORS OR OMISSIONS THAT MAY AFFECT CONSTRUCTION. IT IS THE RESPONSIBILITY OF THE GENERAL CONTRACTOR / BUILDER TO CHECK AND VERIFY ALL SIZES, DIMENSIONS AND COSTRUCTION DETAILS PRIOR TO ANY CONSTRUCTION. ALL DISCREPANCIES TO BE REPORTED TO LIKEHOMEDESIGN.COM INC. FOR CLARIFICATION PRIOR TO CONSTRUCTION. DO NOT SCALE DRAWINGS. VARIATIONS AND MODIFICATIONS TO WORK SHOWN ON THESE DRAWINGS SHALL NOT BE CARRIED OUT WITHOUT WRITTEN PERMISSION FROM LIKEHOMEDESIGN.COM INC.

LIKEHOMEDESIGN.COM INC. WAVES ALL REPONSIBILITY REGARDING ANY STRUCTURAL ENGINEERING AND ONSITE CONDITIONS SUCH AS SOIL BEARING CAPACITY, DEPTH OF FROST LINE, WATER TABLES. ALL ENGINEERING AND ENGINEERS STAMP TO BE THE SOLE RESPONSIBILITY OF BUILDER AND/OR OWNER. THESE PLANS, DESIGNS, AND DETAILS ARE THE PROPERTY OF LIKEHOMEDESIG.COM INC. AND MAY NOT BE REPRODUCED OR USED BY ANYONE, EITHER IN TOTAL OR IN PART, WITHOUT WRITTEN CONSENT FROM LIKEHOMEDESIG.COM INC.

CLIENT/BUILDER

BUILDER PROJECT #

BUILDER PROJECT NAME:

ADDRESS

LEGAL

ABEL & CHRISTINE

RESIDENCE

PROJECT #

855

STATUS

ISSUED FOR PERMITS

DATE

MARCH 28, 2022

DRAWN BY

OP

CHECKED BY


IT

SCALE

As indicated

GENERAL INFO

A2

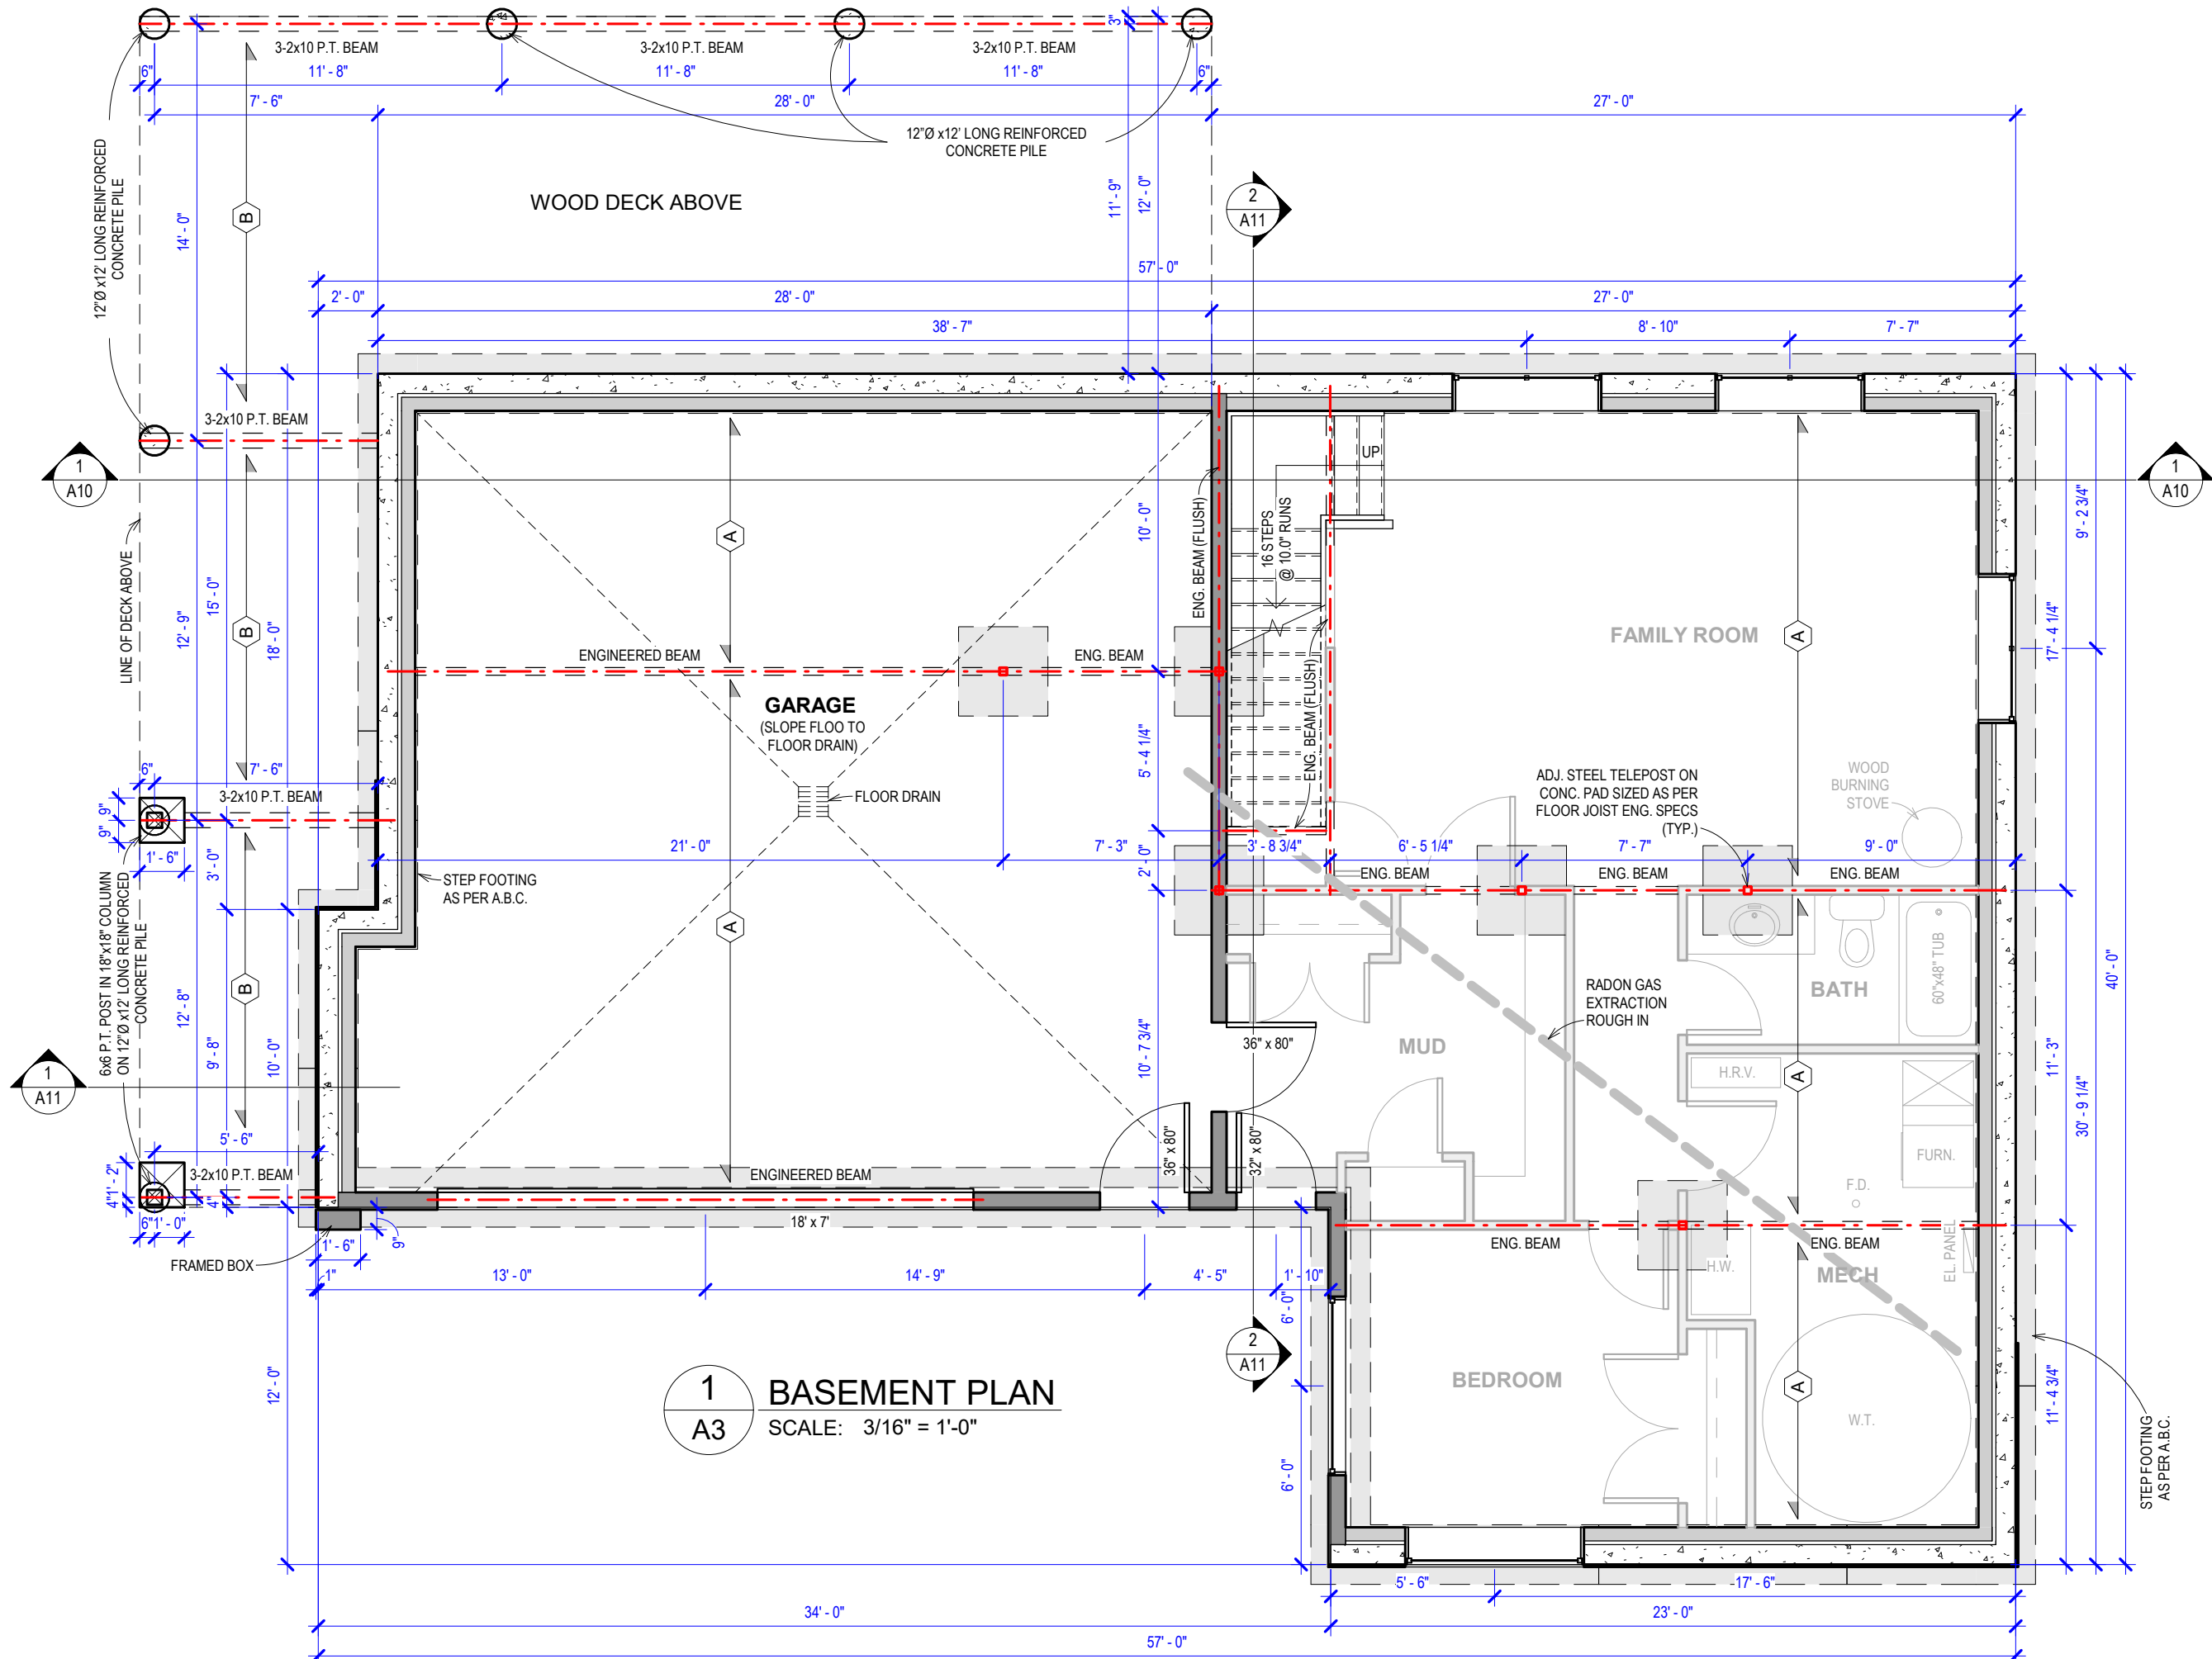

easy to read house plans
LikeHomeDesign.com Inc.
780.757.6543
stock plans - custom house - multi-unit
additions - commercial - industrial

LIKEHOMEDESIGN.COM INC. ASSUMES NO LIABILITY FOR ERRORS OR OMISSIONS THAT MAY AFFECT CONSTRUCTION. IT IS THE RESPONSIBILITY OF THE GENERAL CONTRACTOR / BUILDER TO CHECK AND VERIFY ALL SIZES, DIMENSIONS AND CONSTRUCTION DETAILS PRIOR TO ANY CONSTRUCTION. ALL DISCREPANCIES TO BE REPORTED TO LIKEHOMEDESIGN.COM INC. FOR CLARIFICATION PRIOR TO CONSTRUCTION. DO NOT SCALE DRAWINGS. VARIATIONS AND MODIFICATIONS TO WORK SHOWN ON THESE DRAWINGS SHALL NOT BE CARRIED OUT WITHOUT WRITTEN PERMISSION FROM LIKEHOMEDESIGN.COM INC.

LIKEHOMEDESIGN.COM INC. WAIVES ALL RESPONSIBILITY REGARDING ANY STRUCTURAL ENGINEERING AND ONSITE CONDITIONS SUCH AS SOIL BEARING CAPACITY, DEPTH OF FROST LINE, WATER TABLES. ALL ENGINEERING AND ENGINEERS STAMP TO BE THE SOLE RESPONSIBILITY OF BUILDER AND/OR OWNER. THESE PLANS, DESIGNS, AND DETAILS ARE THE PROPERTY OF LIKEHOMEDESIGN.COM INC. AND MAY NOT BE REPRODUCED OR USED BY ANYONE, EITHER IN TOTAL OR IN PART, WITHOUT WRITTEN CONSENT FROM LIKEHOMEDESIGN.COM INC.


CLIENT/BUILDER
BUILDER PROJECT #
BUILDER PROJECT NAME:
ADDRESS
LEGAL

**ABEL & CHRISTINE
RESIDENCE**

PROJECT # 855
STATUS ISSUED FOR PERMITS
DATE MARCH 28, 2022
DRAWN BY OP
CHECKED BY IT
SCALE 3/16" = 1'-0"

FOUNDATION WALL

A3

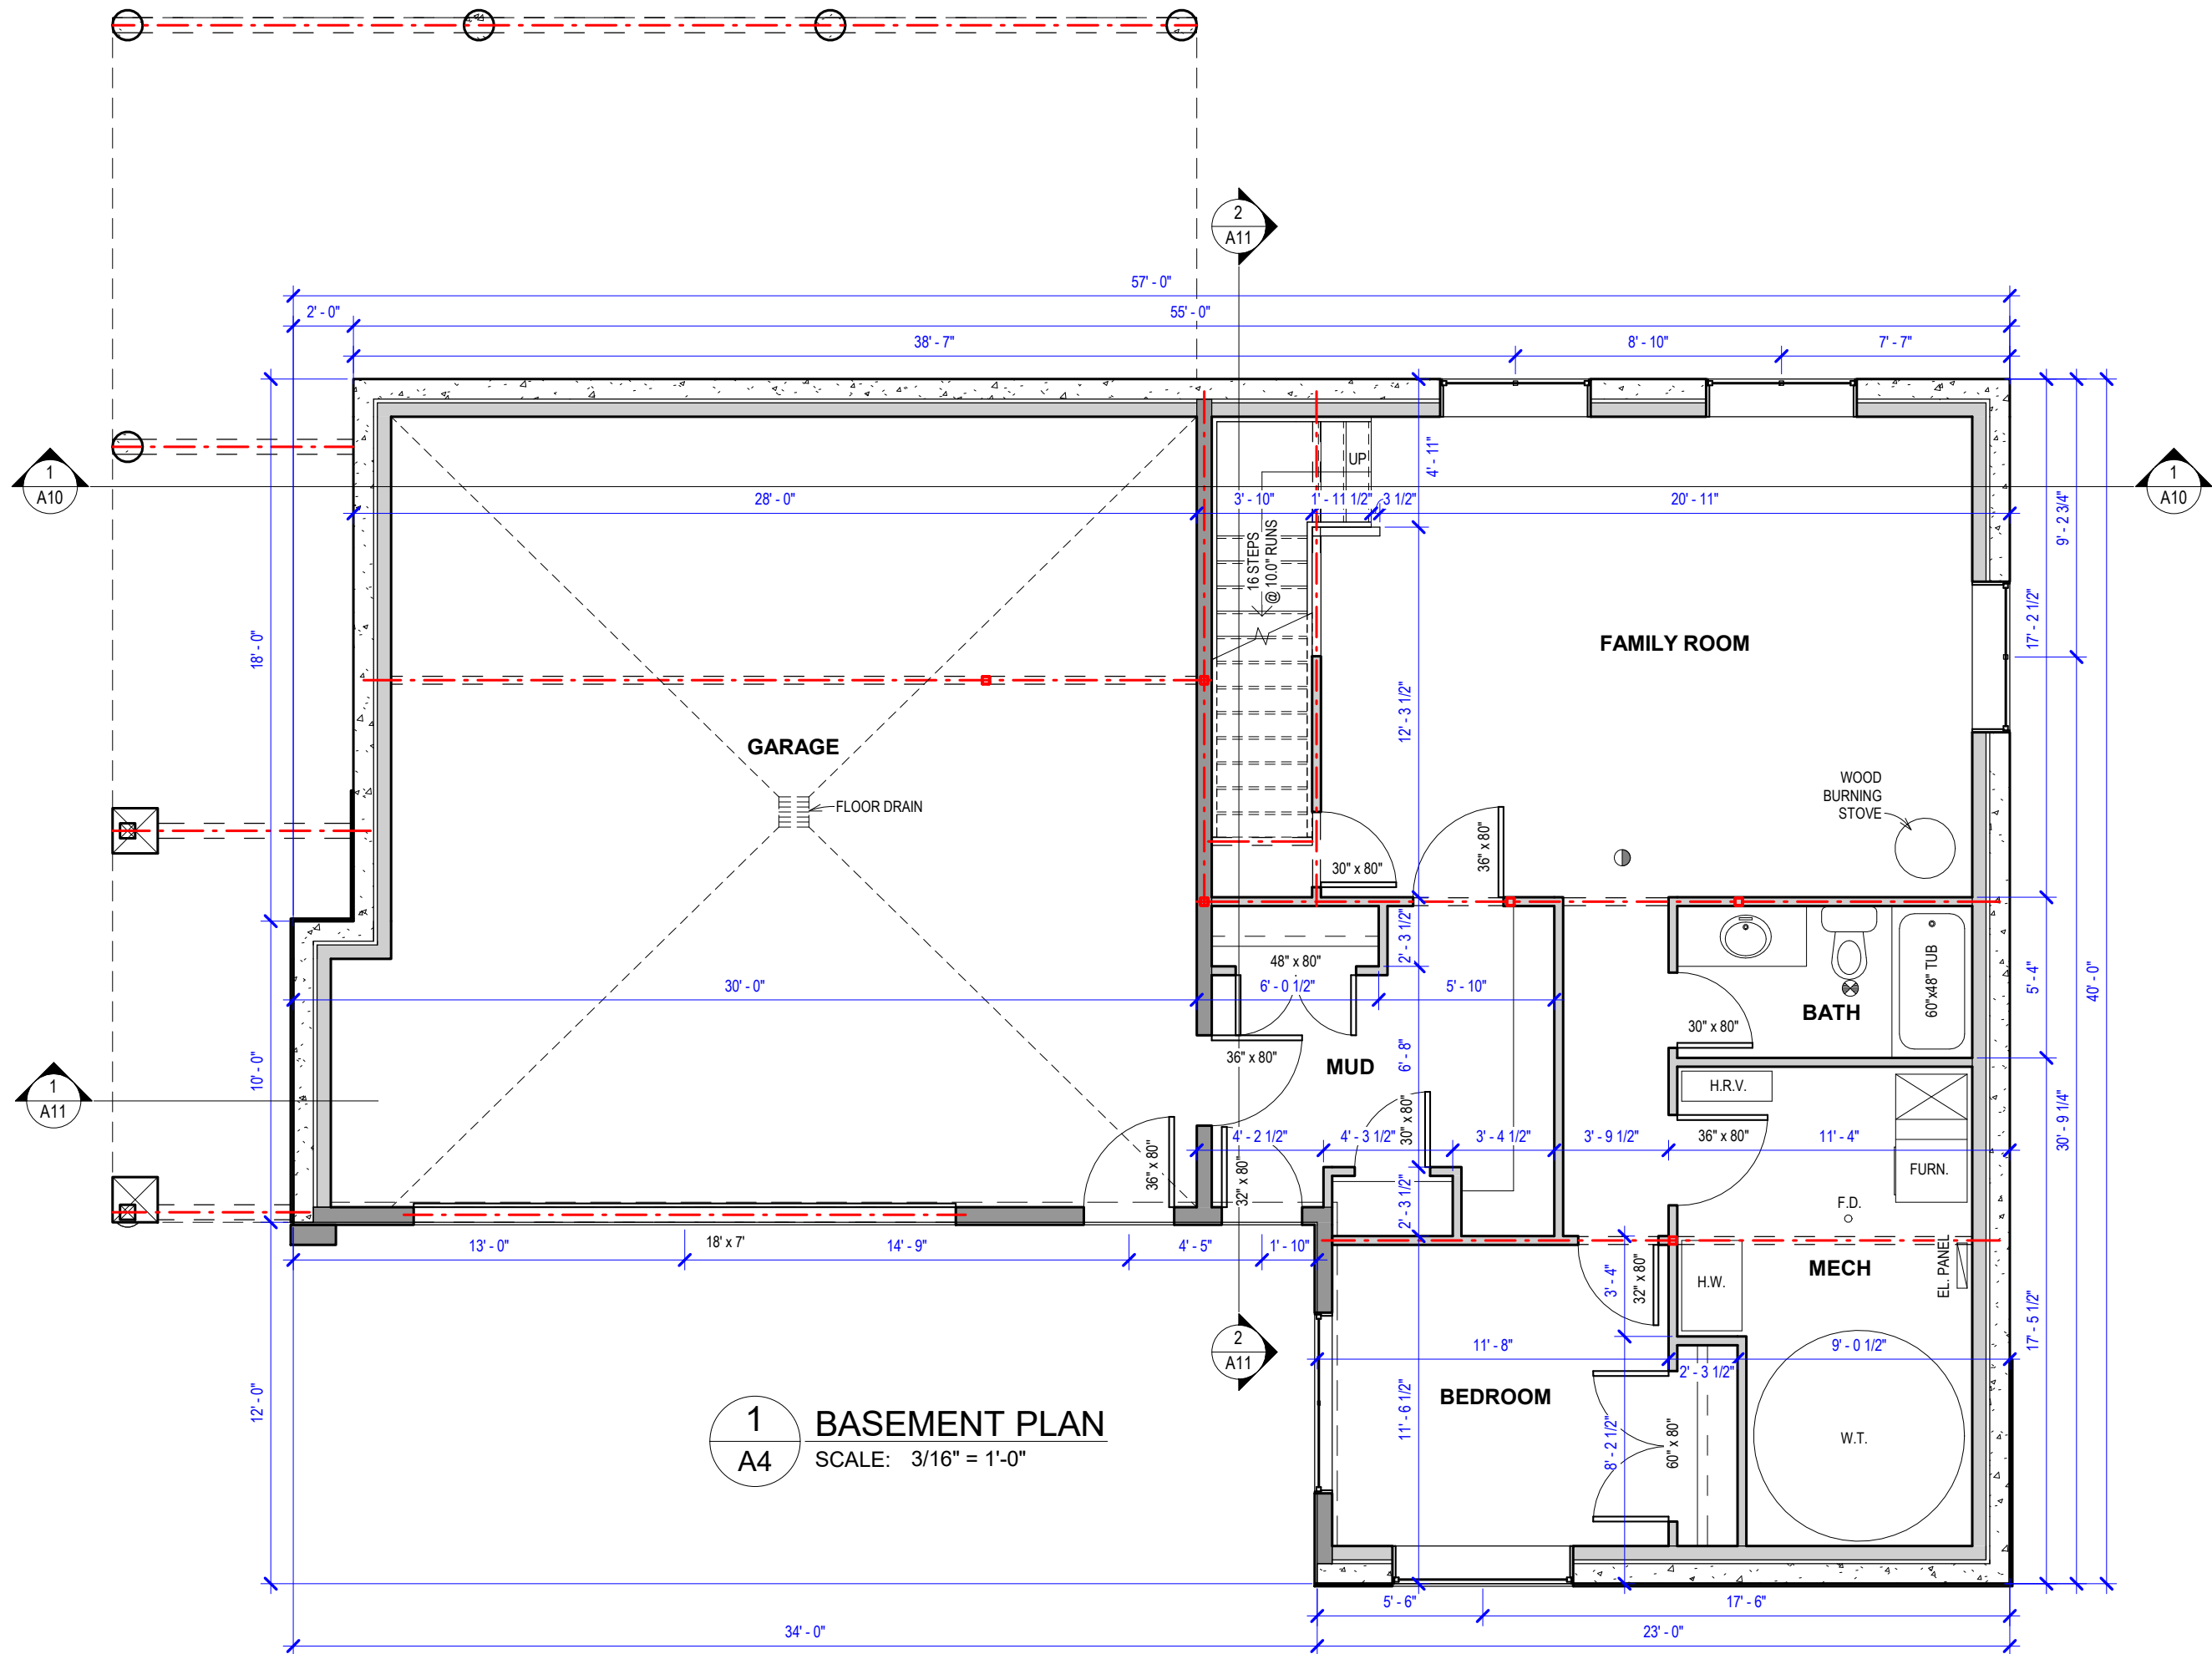

easy to read house plans
LikeHomeDesign.com Inc.
780.757.6543
stock plans - custom house - multi-unit
additions - commercial - industrial

LIKEHOMEDESIGN.COM INC. ASSUMES NO LIABILITY FOR ERRORS OR OMISSIONS THAT MAY AFFECT CONSTRUCTION. IT IS THE RESPONSIBILITY OF THE GENERAL CONTRACTOR / BUILDER TO CHECK AND VERIFY ALL SIZES, DIMENSIONS AND COSTRUCTION DETAILS PRIOR TO ANY CONSTRUCTION. ALL DISCREPANCIES TO BE REPORTED TO LIKEHOMEDESIGN.COM INC. FOR CLARIFICATION PRIOR TO CONSTRUCTION. DO NOT SCALE DRAWINGS. VARIATIONS AND MODIFICATIONS TO WORK SHOWN ON THESE DRAWINGS SHALL NOT BE CARRIED OUT WITHOUT WRITTEN PERMISSION FROM LIKEHOMEDESIGN.COM INC.

LIKEHOMEDESIGN.COM INC. WAIVES ALL RESPONSIBILITY REGARDING ANY STRUCTURAL ENGINEERING AND ONSITE CONDITIONS SUCH AS SOIL BEARING CAPACITY, DEPTH OF FROST LINE, WATER TABLES. ALL ENGINEERING AND ENGINEERS STAMP TO BE THE SOLE RESPONSIBILITY OF BUILDER AND/OR OWNER. THESE PLANS, DESIGNS, AND DETAILS ARE THE PROPERTY OF LIKEHOMEDESIGN.COM INC. AND MAY NOT BE REPRODUCED OR USED BY ANYONE, EITHER IN TOTAL OR IN PART, WITHOUT WRITTEN CONSENT FROM LIKEHOMEDESIGN.COM INC.

CLIENT/BUILDER
BUILDER PROJECT #
BUILDER PROJECT NAME:


ADDRESS
LEGAL

**ABEL & CHRISTINE
RESIDENCE**


PROJECT # 855
STATUS ISSUED FOR PERMITS
DATE MARCH 28, 2022
DRAWN BY OP
CHECKED BY IT
SCALE 3/16" = 1'-0"

BASEMENT PLAN

A4

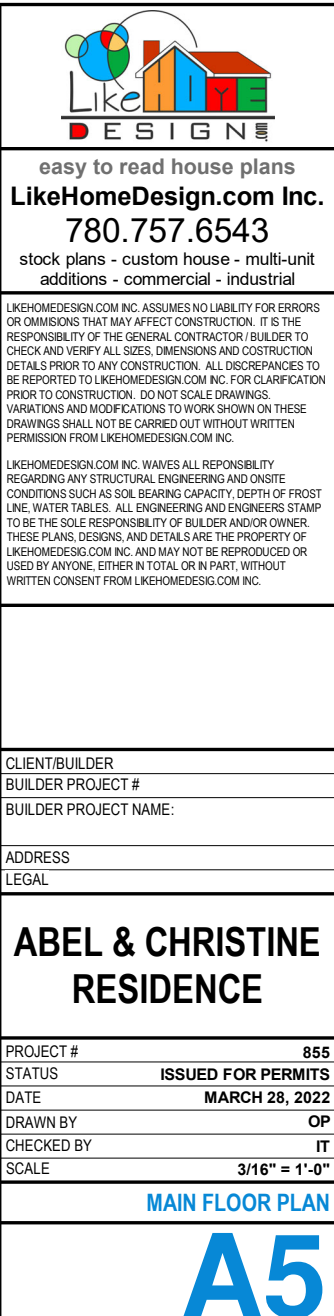



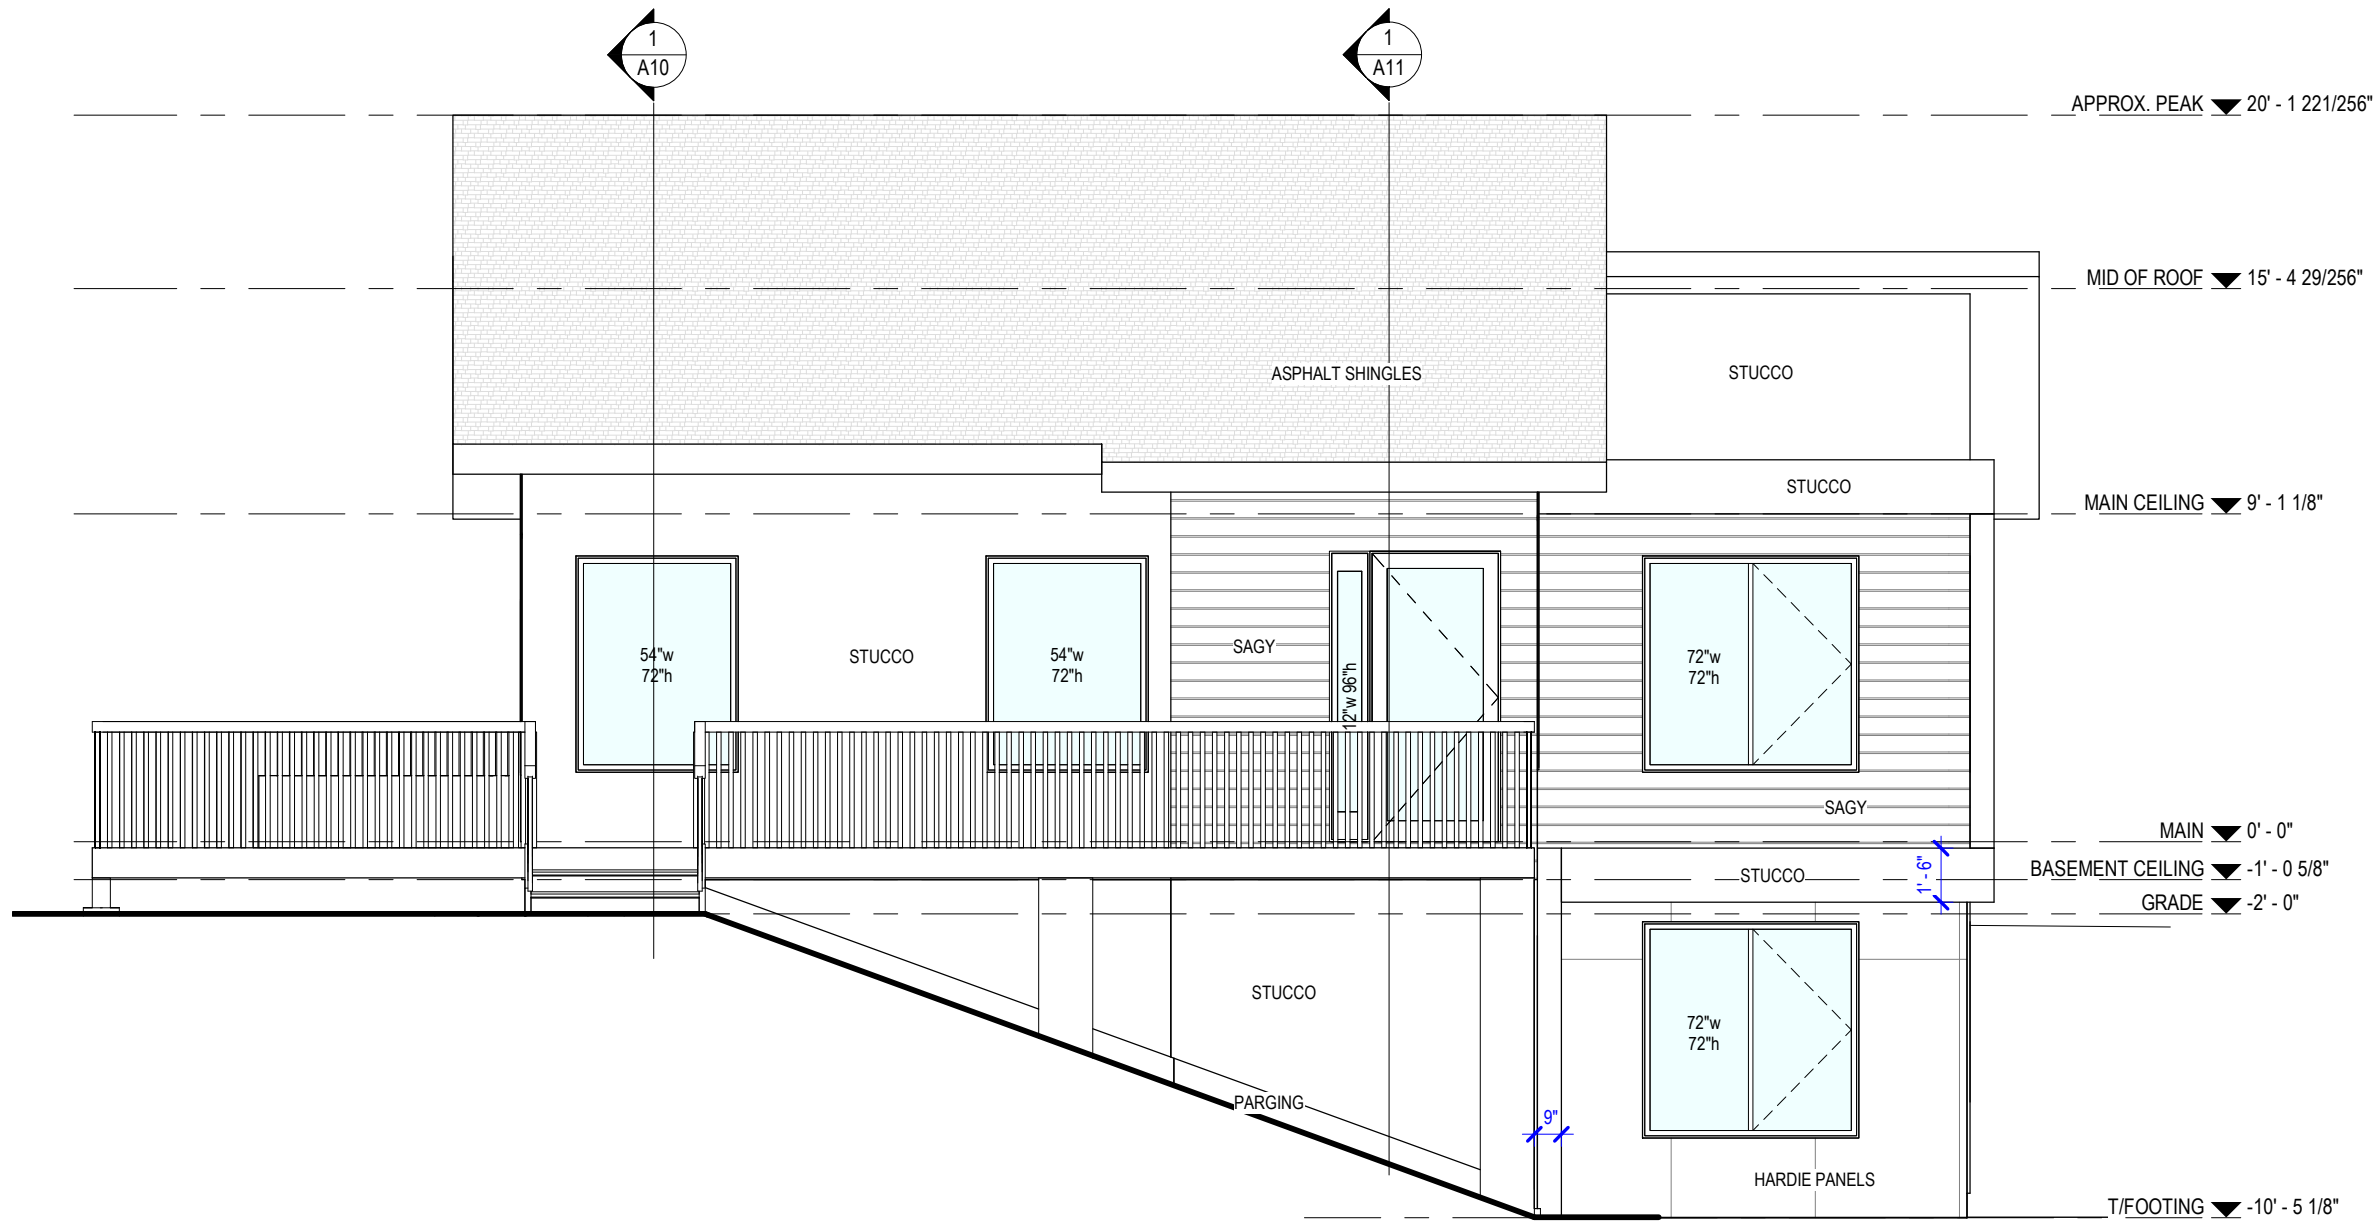

1 LEFT
A7 SCALE: 3/16" = 1'-0"



easy to read house plans
LikeHomeDesign.com Inc.
780.757.6543
stock plans - custom house - multi-unit
additions - commercial - industrial

LIKEHOMEDESIGN.COM INC. ASSUMES NO LIABILITY FOR ERRORS OR OMISSIONS THAT MAY AFFECT CONSTRUCTION. IT IS THE RESPONSIBILITY OF THE GENERAL CONTRACTOR / BUILDER TO CHECK AND VERIFY ALL SIZES, DIMENSIONS AND CONSTRUCTION DETAILS PRIOR TO ANY CONSTRUCTION. ALL DISCREPANCIES TO BE REPORTED TO LIKEHOMEDESIGN.COM INC. FOR CLARIFICATION PRIOR TO CONSTRUCTION. DO NOT SCALE DRAWINGS. VARIATIONS AND MODIFICATIONS TO WORK SHOWN ON THESE DRAWINGS SHALL NOT BE CARRIED OUT WITHOUT WRITTEN PERMISSION FROM LIKEHOMEDESIGN.COM INC.


LIKEHOMEDESIGN.COM INC. WAIVES ALL RESPONSIBILITY REGARDING ANY STRUCTURAL ENGINEERING AND ON-SITE CONDITIONS SUCH AS SOIL BEARING CAPACITY, DEPTH OF FROST LINE, WATER TABLES, ALL ENGINEERING AND ENGINEERS STAMP TO BE THE SOLE RESPONSIBILITY OF BUILDER AND/OR OWNER. THESE PLANS, DESIGNS, AND DETAILS ARE THE PROPERTY OF LIKEHOMEDESIGN.COM INC. AND MAY NOT BE REPRODUCED OR USED BY ANYONE, EITHER IN TOTAL OR IN PART, WITHOUT WRITTEN CONSENT FROM LIKEHOMEDESIGN.COM INC.

CLIENT/BUILDER
BUILDER PROJECT #
BUILDER PROJECT NAME:
ADDRESS
LEGAL

ABEL &
CHRISTINE
RESIDENCE

PROJECT # 855
STATUS ISSUED FOR PERMITS
DATE MARCH 28, 2022
DRAWN BY OP
CHECKED BY IT
SCALE 3/16" = 1'-0"

LEFT ELEVATION
A7

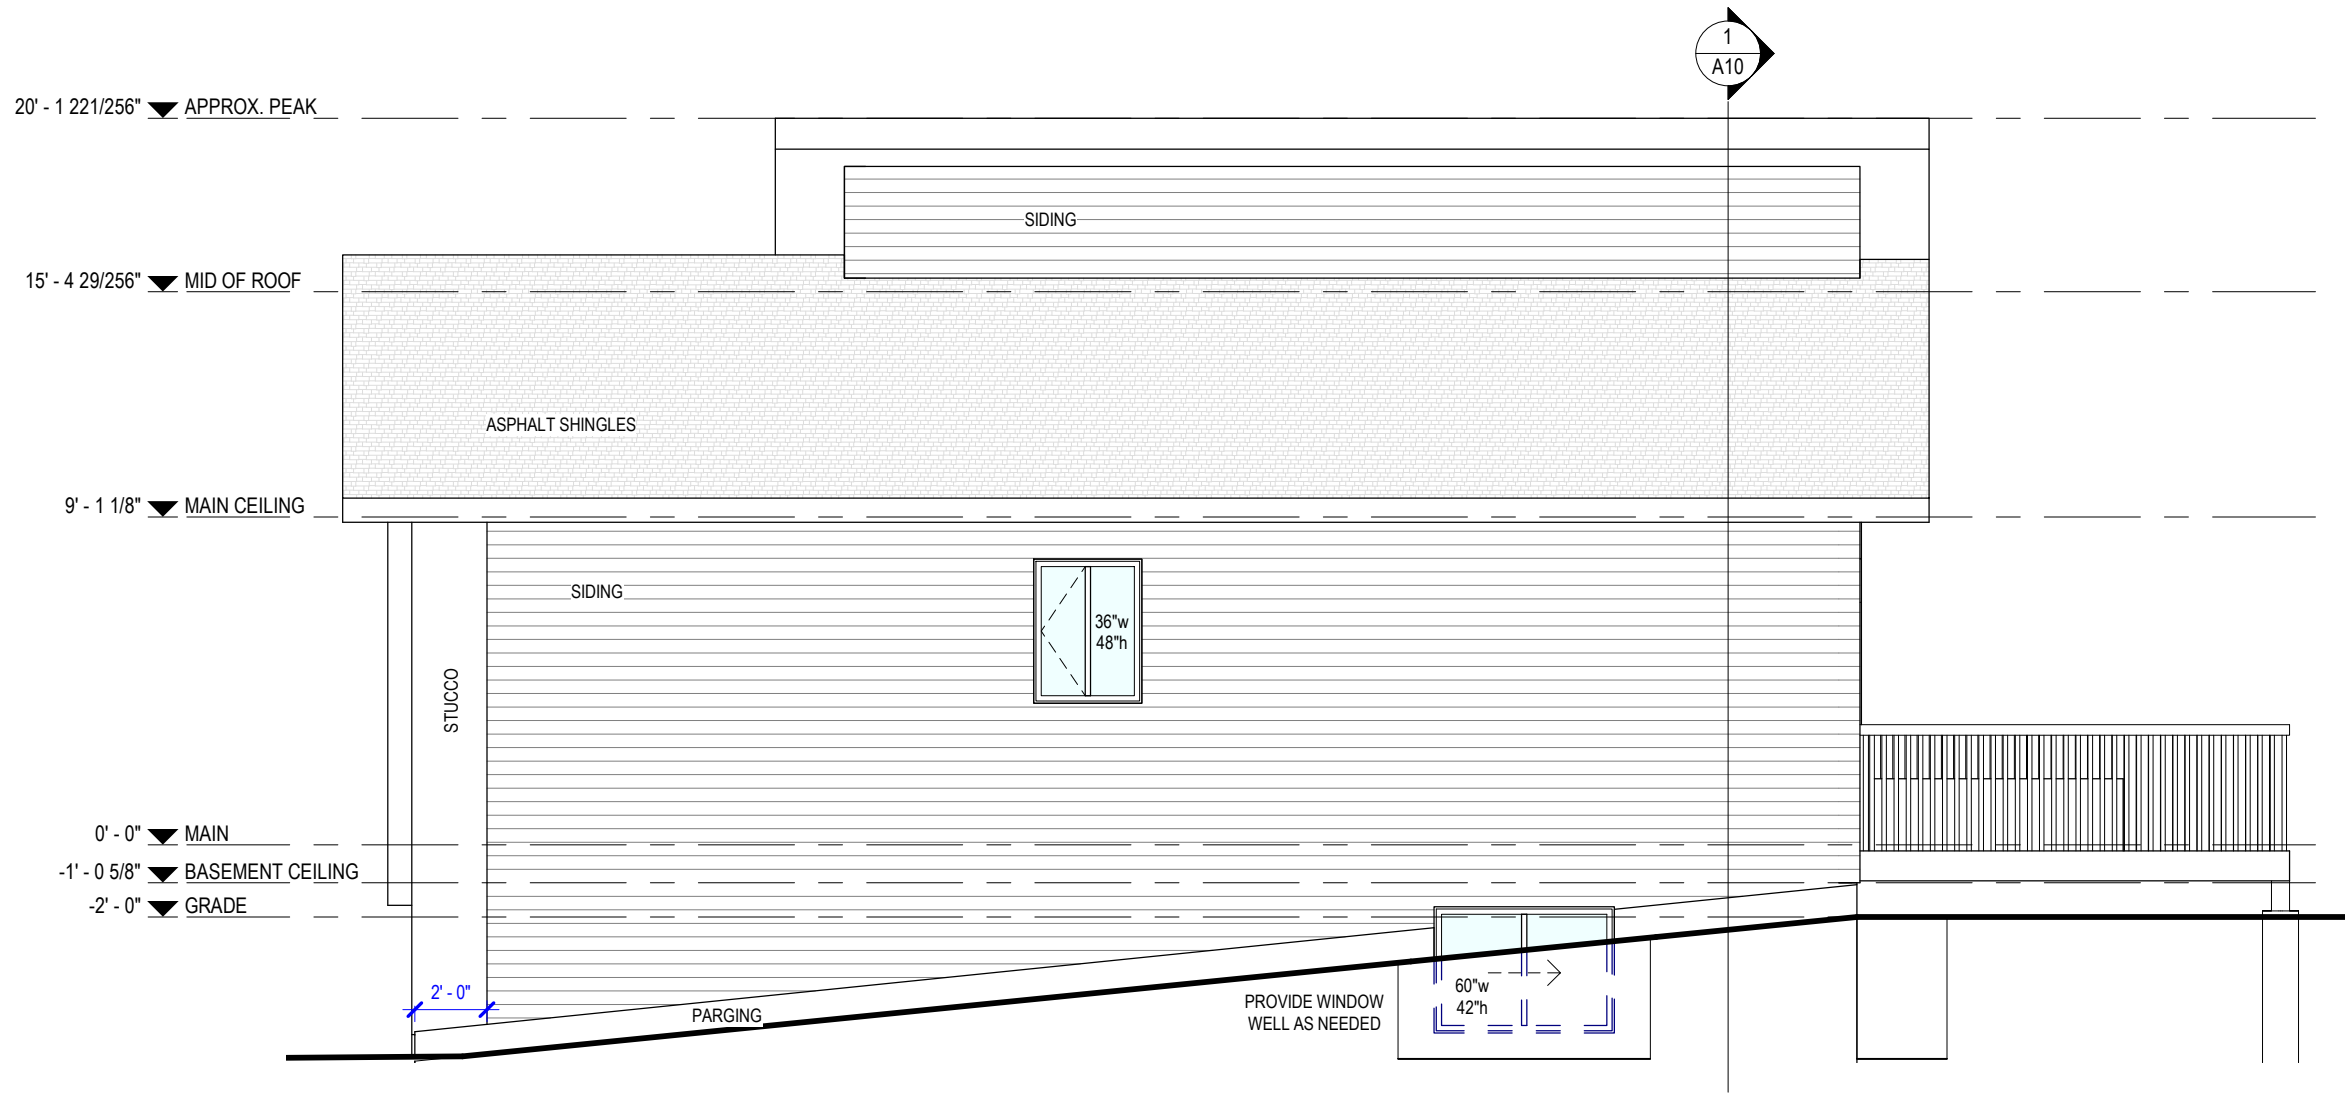

1 RIGHT
A8 SCALE: 3/16" = 1'-0"



easy to read house plans
LikeHomeDesign.com Inc.
780.757.6543
stock plans - custom house - multi-unit
additions - commercial - industrial

LIKEHOMEDESIGN.COM INC. ASSUMES NO LIABILITY FOR ERRORS OR OMISSIONS THAT MAY AFFECT CONSTRUCTION. IT IS THE RESPONSIBILITY OF THE GENERAL CONTRACTOR / BUILDER TO CHECK AND VERIFY ALL SIZES, DIMENSIONS AND CONSTRUCTION DETAILS PRIOR TO ANY CONSTRUCTION. ALL DISCREPANCIES TO BE REPORTED TO LIKEHOMEDESIGN.COM INC. FOR CLARIFICATION PRIOR TO CONSTRUCTION. DO NOT SCALE DRAWINGS. VARIATIONS AND MODIFICATIONS TO WORK SHOWN ON THESE DRAWINGS SHALL NOT BE CARRIED OUT WITHOUT WRITTEN PERMISSION FROM LIKEHOMEDESIGN.COM INC.


LIKEHOMEDESIGN.COM INC. WAIVES ALL RESPONSIBILITY REGARDING ANY STRUCTURAL ENGINEERING AND ONSITE CONDITIONS SUCH AS SOIL BEARING CAPACITY, DEPTH OF FROST LINE, WATER TABLES. ALL ENGINEERING AND ENGINEERS STAMP TO BE THE SOLE RESPONSIBILITY OF BUILDER AND/OR OWNER. THESE PLANS, DESIGNS, AND DETAILS ARE THE PROPERTY OF LIKEHOMEDESIGN.COM INC. AND MAY NOT BE REPRODUCED OR USED BY ANYONE, EITHER IN TOTAL OR IN PART, WITHOUT WRITTEN CONSENT FROM LIKEHOMEDESIGN.COM INC.

CLIENT/BUILDER
BUILDER PROJECT #
BUILDER PROJECT NAME:
ADDRESS
LEGAL


ABEL &
CHRISTINE
RESIDENCE

PROJECT # 855
STATUS ISSUED FOR PERMITS
DATE MARCH 28, 2022
DRAWN BY OP
CHECKED BY IT
SCALE 3/16" = 1'-0"

RIGHT ELEVATION
A8

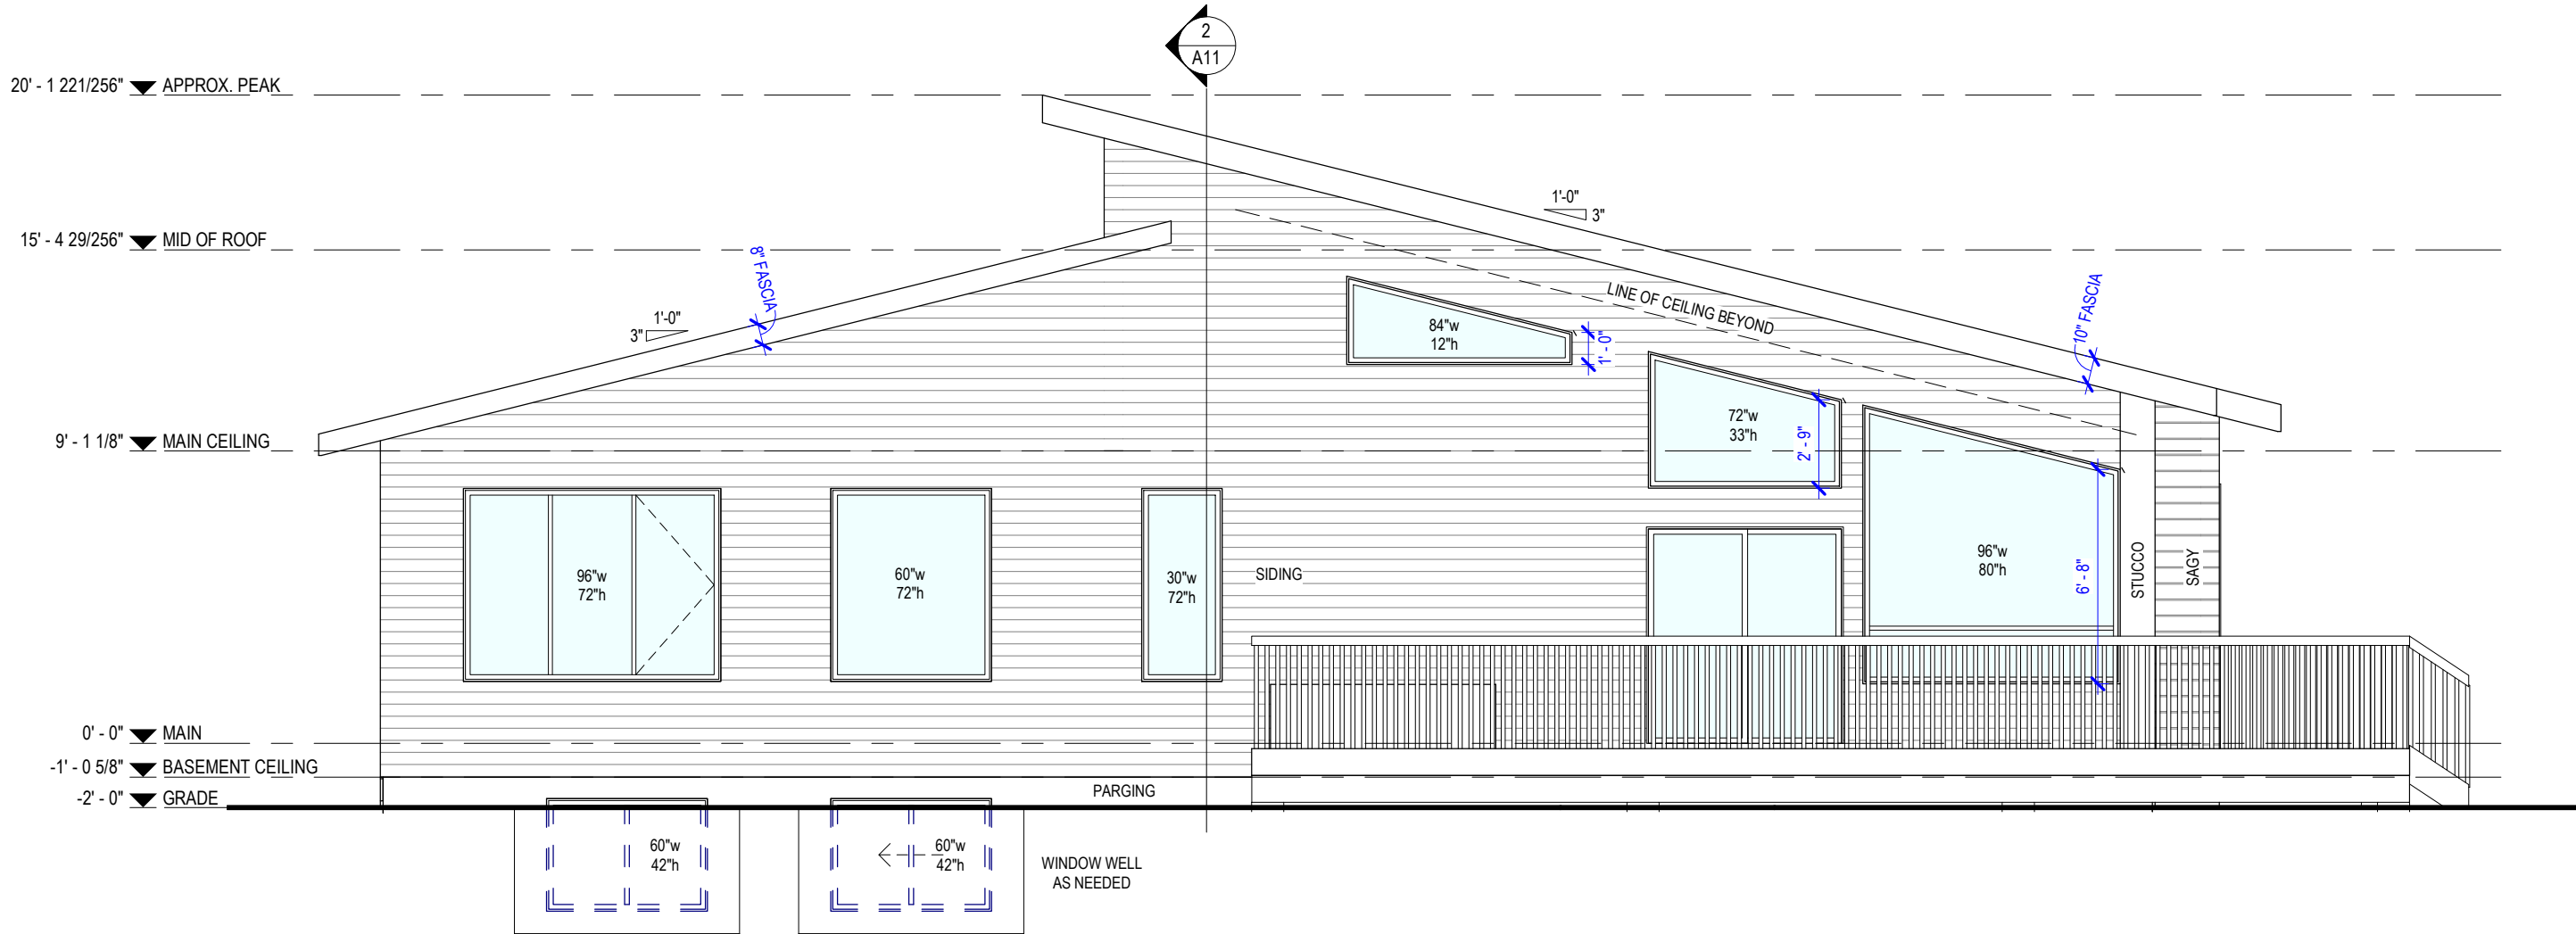

1 REAR
A9 SCALE: 3/16" = 1'-0"

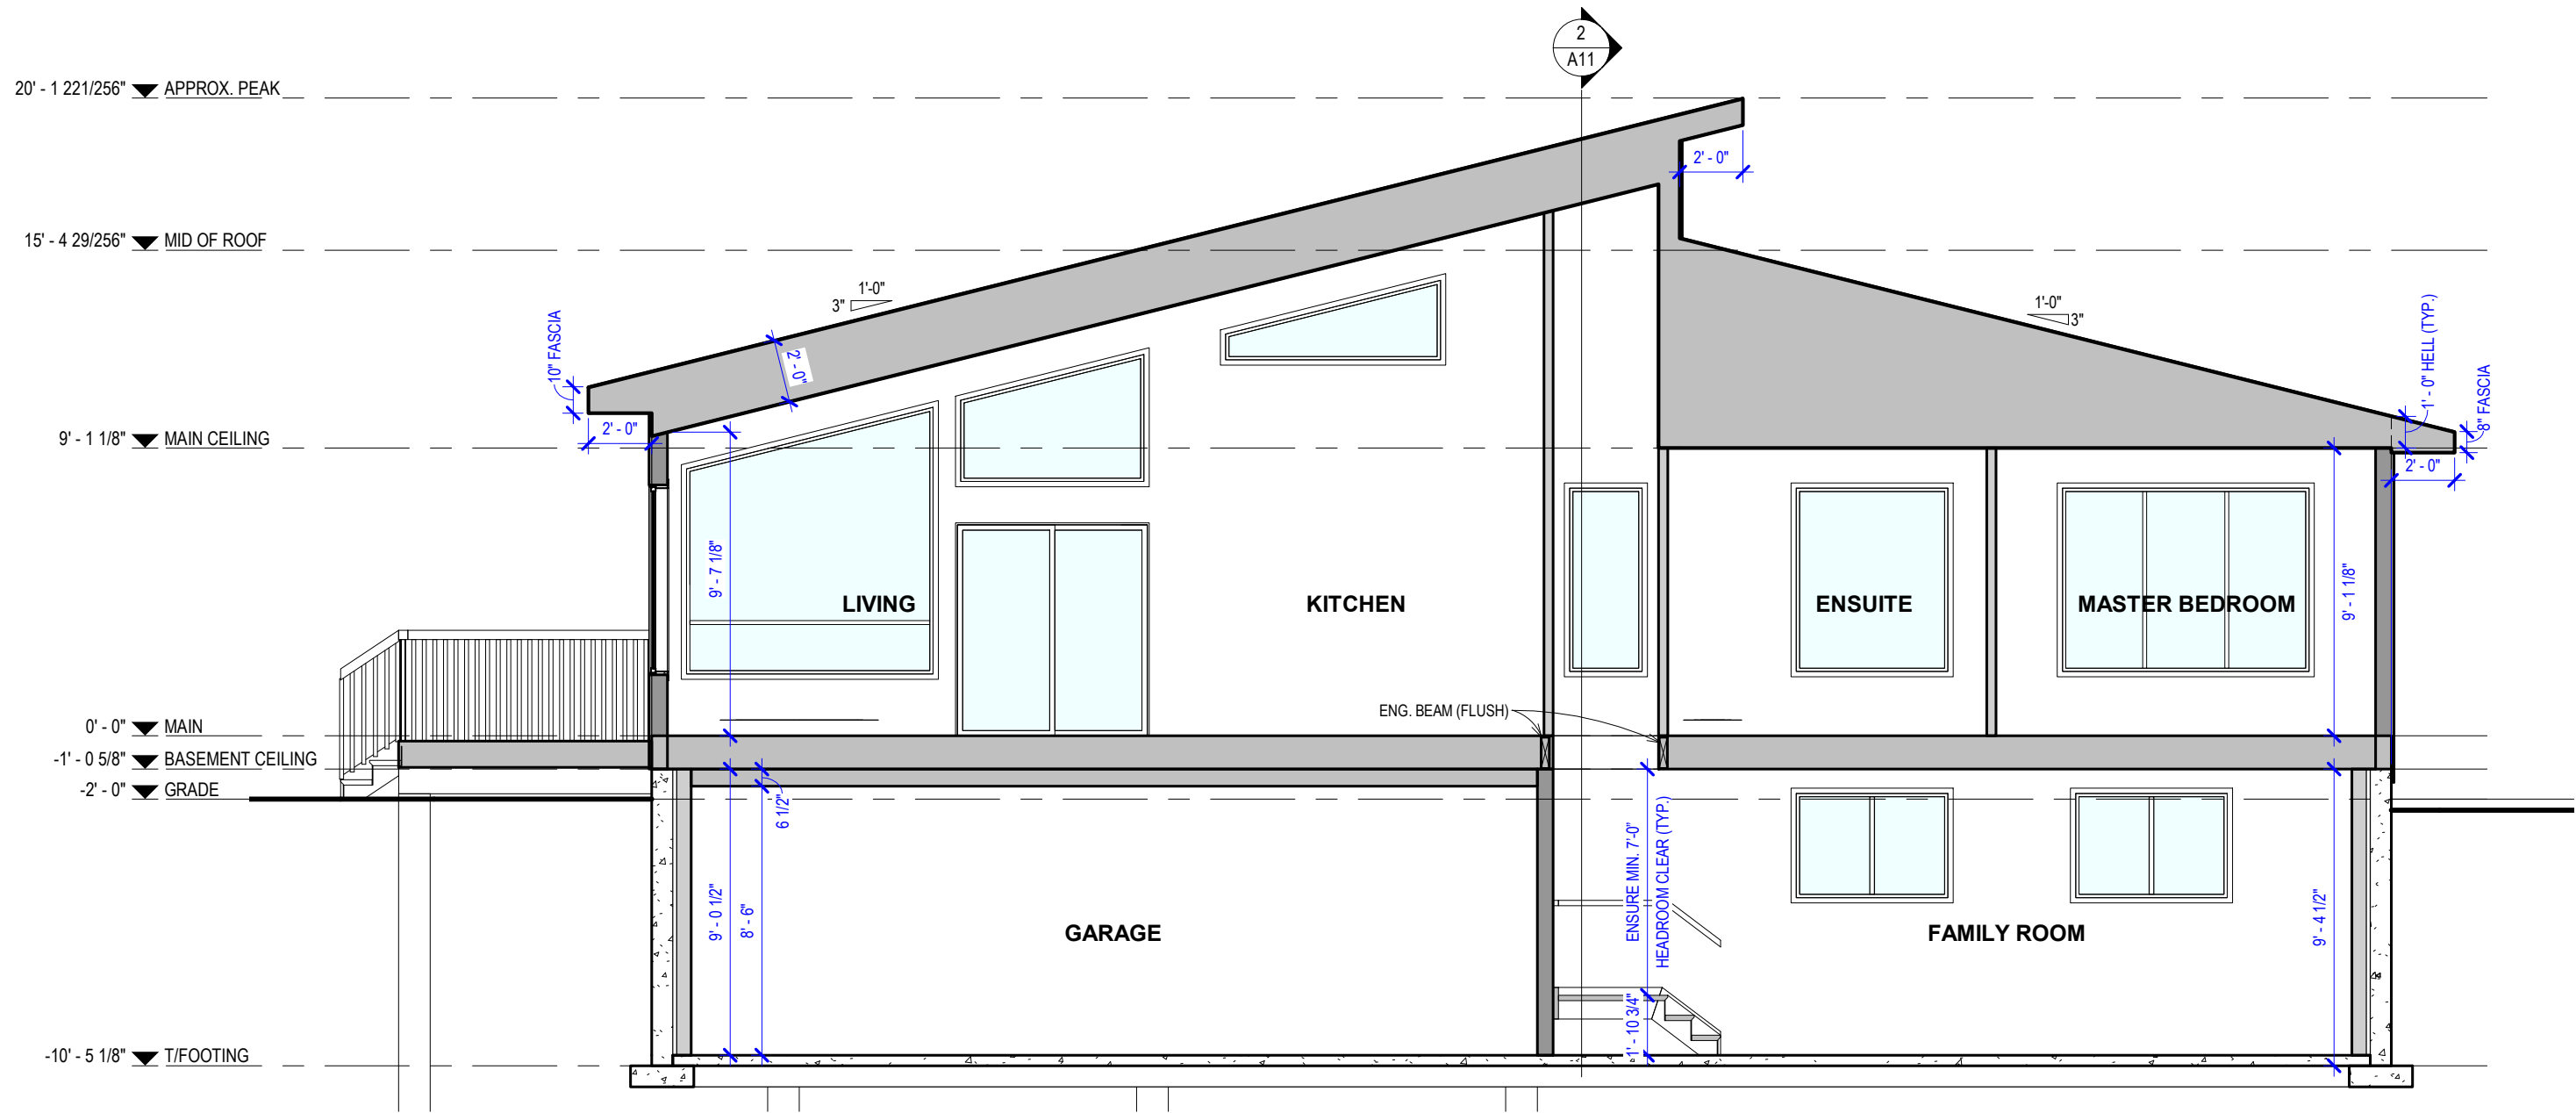

1 SECTION 1
A10 SCALE: 3/16" = 1'-0"



easy to read house plans
LikeHomeDesign.com Inc.
780.757.6543
stock plans - custom house - multi-unit
additions - commercial - industrial

LikeHomeDesign.com Inc. ASSUMES NO LIABILITY FOR ERRORS OR OMISSIONS THAT MAY AFFECT CONSTRUCTION. IT IS THE RESPONSIBILITY OF THE GENERAL CONTRACTOR / BUILDER TO CHECK AND VERIFY ALL SIZES, DIMENSIONS AND CONSTRUCTION DETAILS PRIOR TO ANY CONSTRUCTION. ALL DISCREPANCIES TO BE REPORTED TO LIKEHOMEDESIGN.COM INC. FOR CLARIFICATION PRIOR TO CONSTRUCTION. DO NOT SCALE DRAWINGS. VARIATIONS AND MODIFICATIONS TO WORK SHOWN ON THESE DRAWINGS SHALL NOT BE CARRIED OUT WITHOUT WRITTEN PERMISSION FROM LIKEHOMEDESIGN.COM INC.


LikeHomeDesign.com Inc. WAIVES ALL RESPONSIBILITY REGARDING ANY STRUCTURAL ENGINEERING AND ON-SITE CONDITIONS SUCH AS SOIL BEARING CAPACITY, DEPTH OF FROST LINE, WATER TABLES, ALL ENGINEERING AND ENGINEERS STAMP TO BE THE SOLE RESPONSIBILITY OF BUILDER AND/OR OWNER. THESE PLANS, DESIGNS, AND DETAILS ARE THE PROPERTY OF LIKEHOMEDESIGN.COM INC. AND MAY NOT BE REPRODUCED OR USED BY ANYONE, EITHER IN TOTAL OR IN PART, WITHOUT WRITTEN CONSENT FROM LIKEHOMEDESIGN.COM INC.

CLIENT/BUILDER
BUILDER PROJECT #
BUILDER PROJECT NAME:
ADDRESS
LEGAL

ABEL &
CHRISTINE
RESIDENCE


PROJECT # 855
STATUS ISSUED FOR PERMITS
DATE MARCH 28, 2022
DRAWN BY OP
CHECKED BY IT
SCALE 3/16" = 1'-0"

SECTION 1
A10

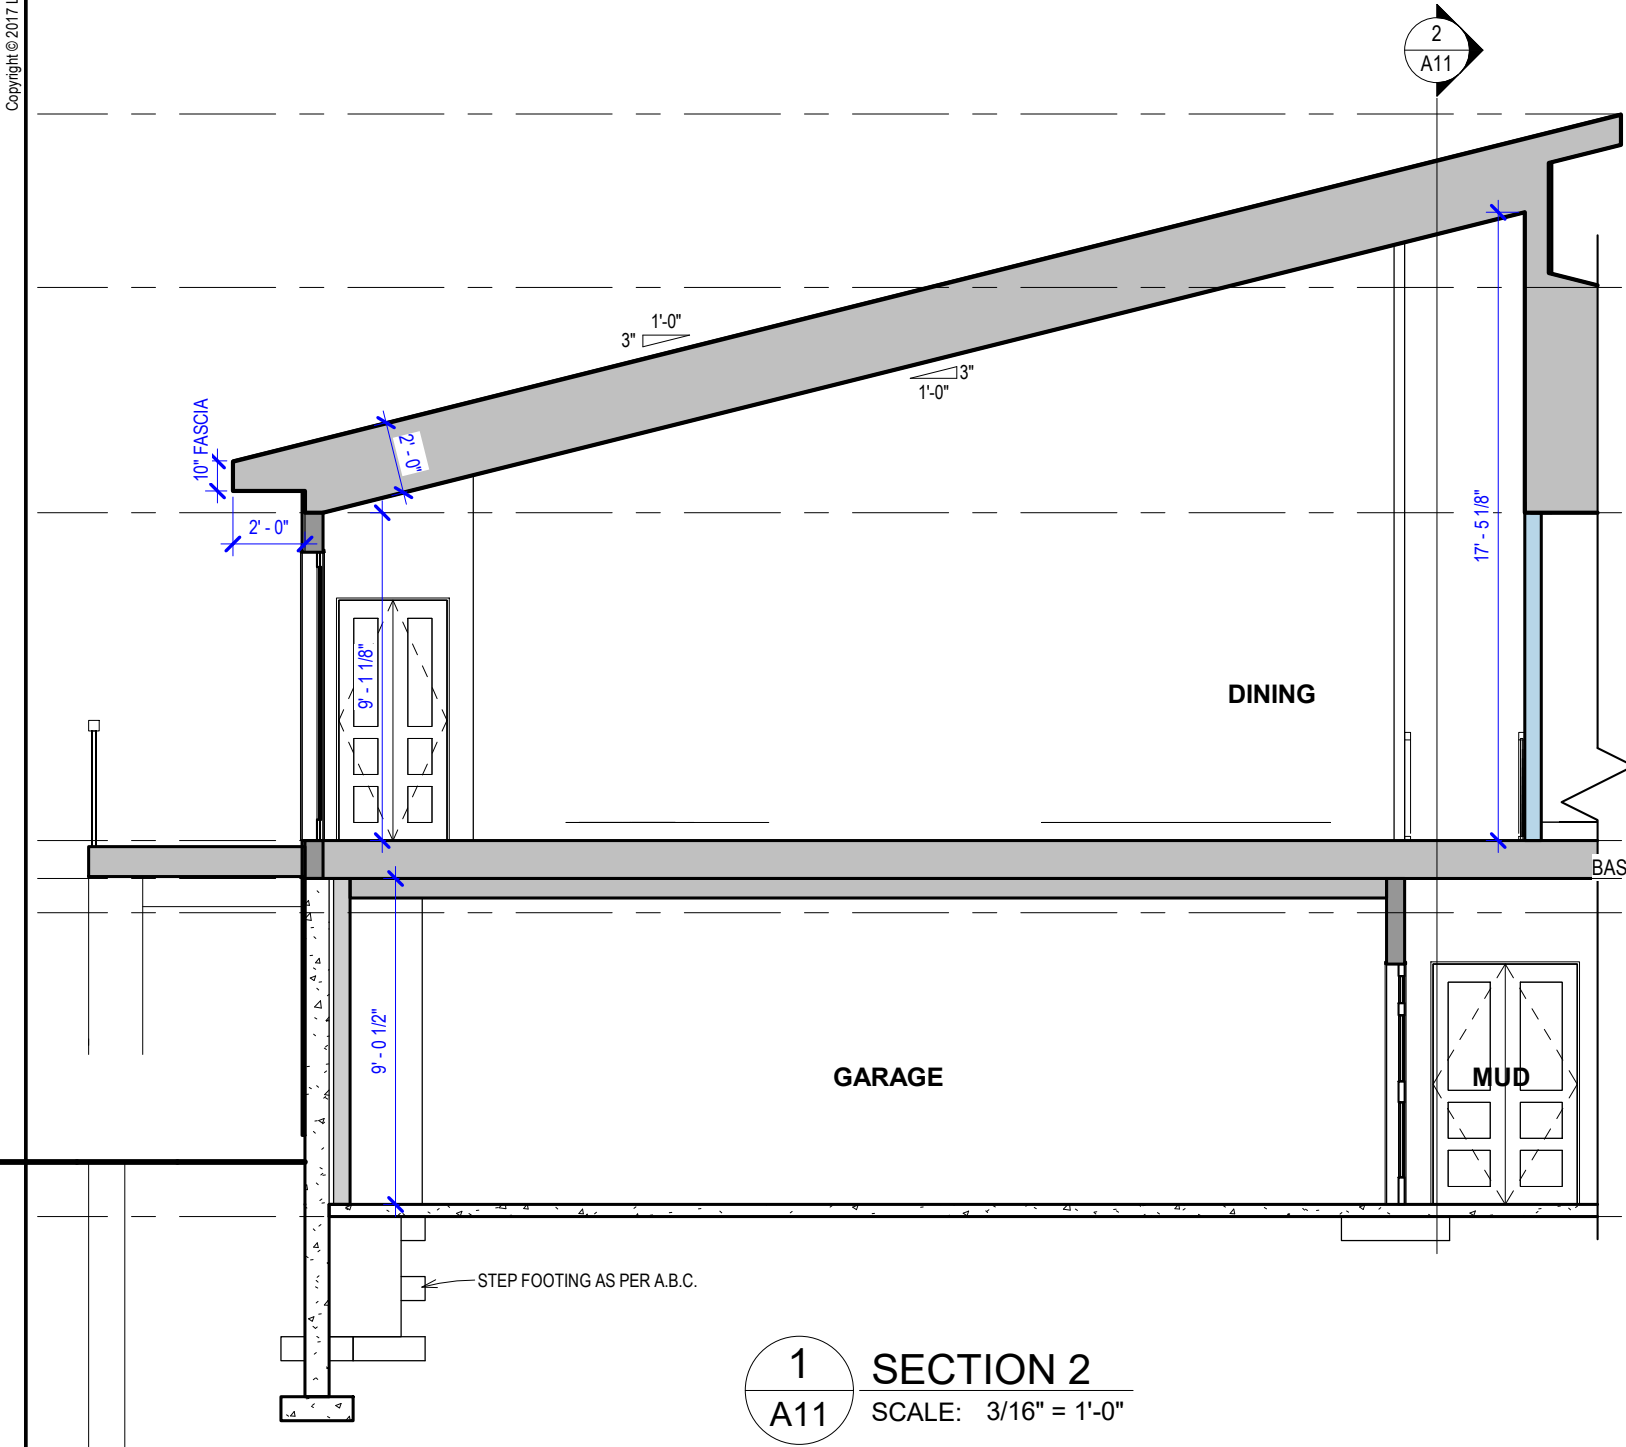

1
A11

SECTION 2
SCALE: 3/16" = 1'-0"

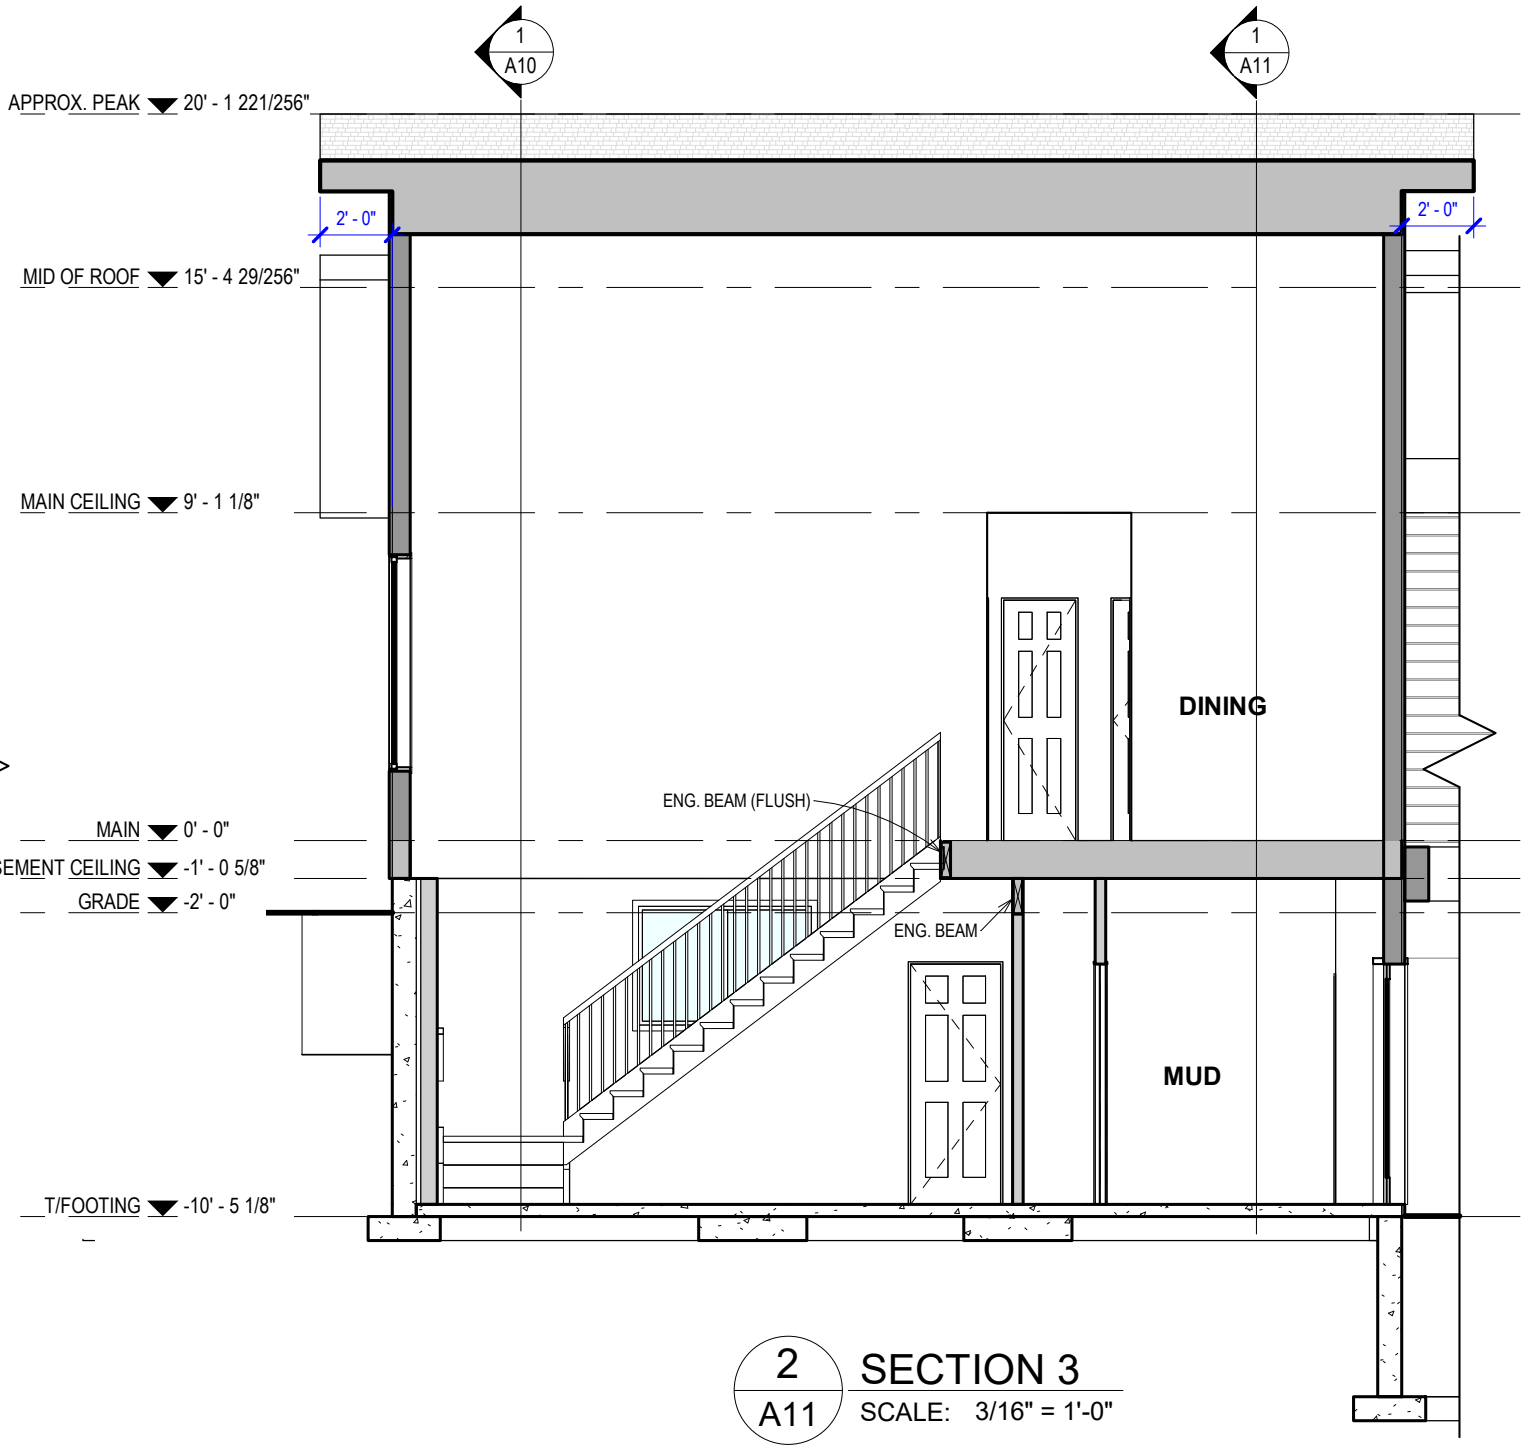

2
A11

SECTION 3
SCALE: 3/16" = 1'-0"



easy to read house plans
LikeHomeDesign.com Inc.
780.757.6543
stock plans - custom house - multi-unit
additions - commercial - industrial

LIKEHOMEDSIGN.COM INC. ASSUMES NO LIABILITY FOR ERRORS OR OMISSIONS THAT MAY AFFECT CONSTRUCTION. IT IS THE RESPONSIBILITY OF THE GENERAL CONTRACTOR / BUILDER TO CHECK AND VERIFY ALL SIZES, DIMENSIONS AND CONSTRUCTION DETAILS PRIOR TO ANY CONSTRUCTION. ALL DISCREPANCIES TO BE REPORTED TO LIKEHOMEDSIGN.COM INC. FOR CLARIFICATION PRIOR TO CONSTRUCTION. DO NOT SCALE DRAWINGS. VARIATIONS AND MODIFICATIONS TO WORK SHOWN ON THESE DRAWINGS SHALL NOT BE CARRIED OUT WITHOUT WRITTEN PERMISSION FROM LIKEHOMEDSIGN.COM INC.

LIKEHOMEDSIGN.COM INC. WAIVES ALL RESPONSIBILITY REGARDING ANY STRUCTURAL ENGINEERING AND ON-SITE CONDITIONS SUCH AS SOIL BEARING CAPACITY, DEPTH OF FROST LINE, WATER TABLES, ALL ENGINEERING AND ENGINEERS STAMP TO BE THE SOLE RESPONSIBILITY OF BUILDER AND/OR OWNER. THESE PLANS, DESIGNS, AND DETAILS ARE THE PROPERTY OF LIKEHOMEDSIGN.COM INC. AND MAY NOT BE REPRODUCED OR USED BY ANYONE, EITHER IN TOTAL OR IN PART, WITHOUT WRITTEN CONSENT FROM LIKEHOMEDSIGN.COM INC.


CLIENT/BUILDER
BUILDER PROJECT #
BUILDER PROJECT NAME:
ADDRESS
LEGAL

**ABEL &
CHRISTINE
RESIDENCE**

PROJECT # 855
STATUS ISSUED FOR PERMITS
DATE MARCH 28, 2022
DRAWN BY OP
CHECKED BY IT
SCALE 3/16" = 1'-0"


SECTIONS 2 & 3
A11

TYPICAL ROOF (SEE ROOF PLAN FOR SLOPE):

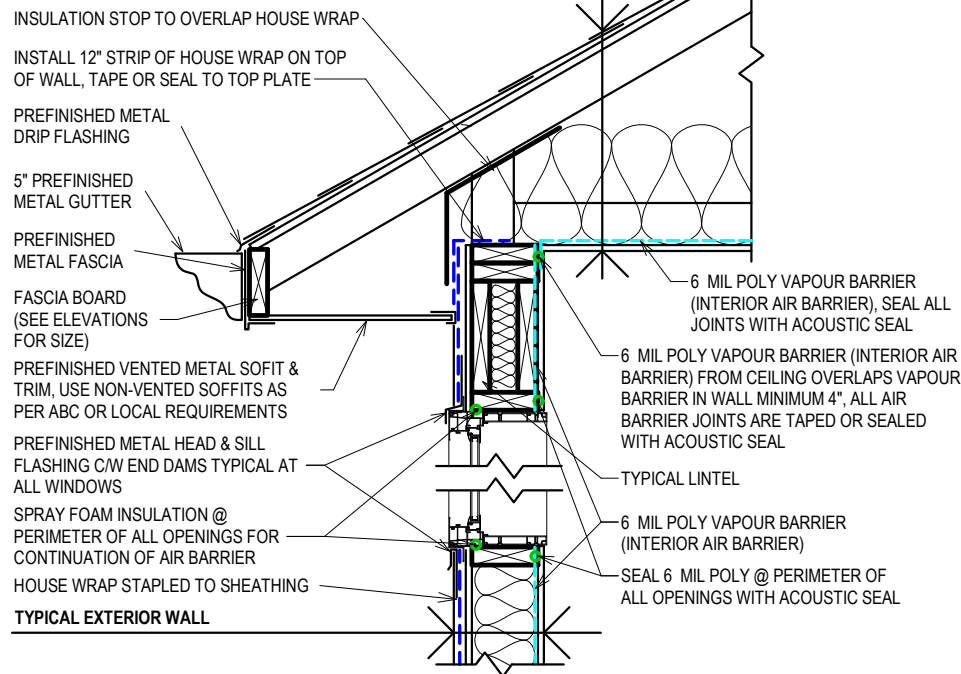


1 TYPICAL ROOF EAVE
A12 SCALE: 3/4" = 1'-0"

TYPICAL ROOF (SEE ROOF PLAN FOR SLOPE)

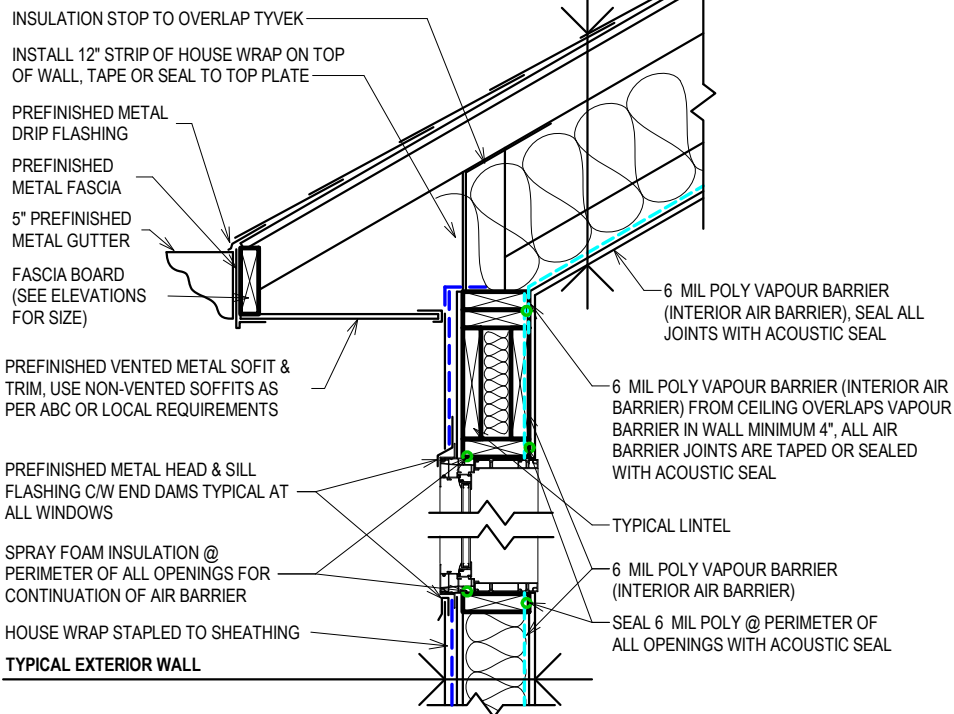


3 ROOF (SLOPED CEILING)
A12 SCALE: 3/4" = 1'-0"

TYPICAL ROOF (SEE ROOF PLAN FOR SLOPE)

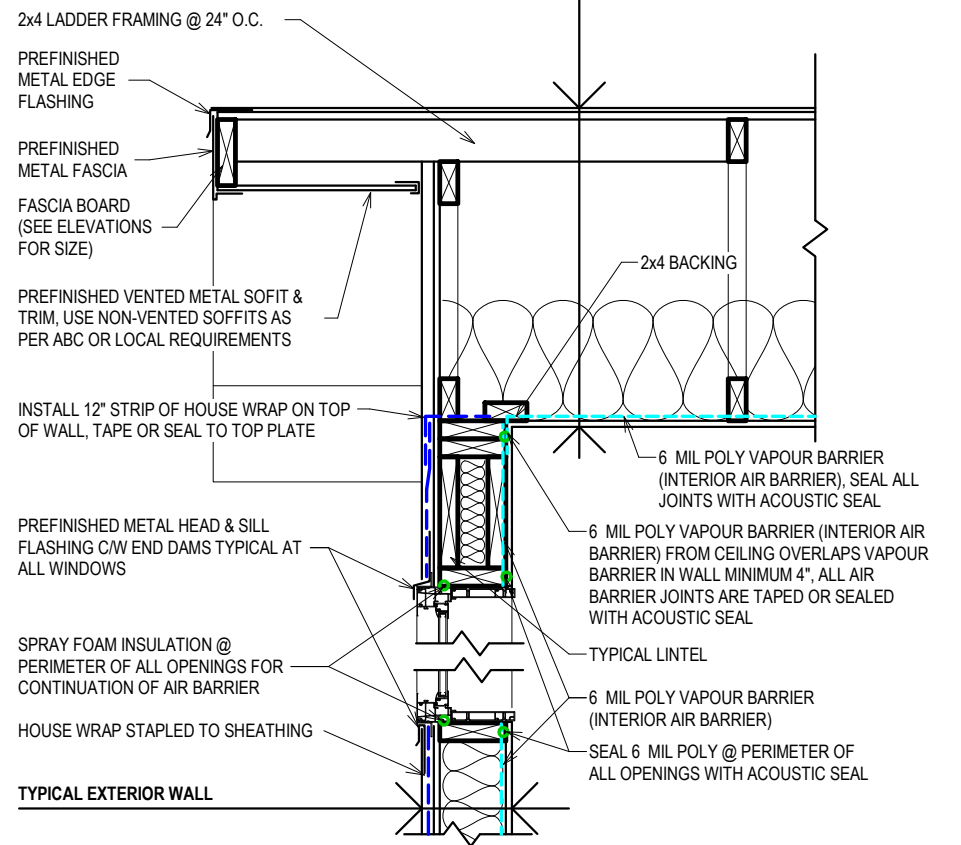


5 TYPICAL ROOF GABLE
A12 SCALE: 3/4" = 1'-0"

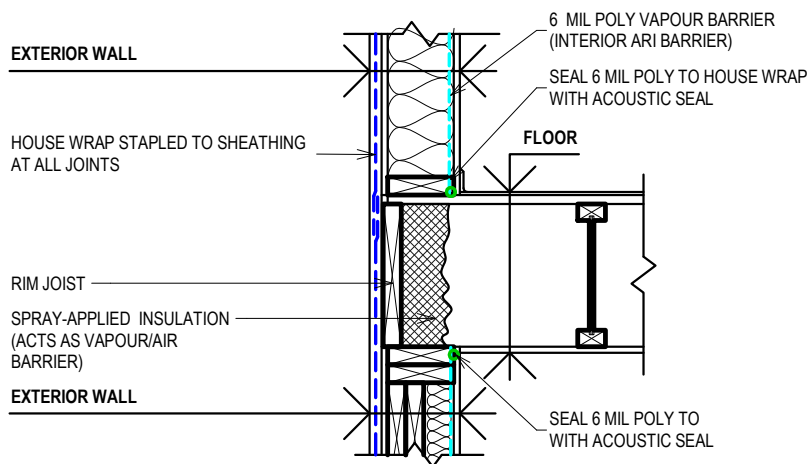


2 RIM BOARD
A12 SCALE: 3/4" = 1'-0"

TYPICAL EXTERIOR BASEMENT WALL

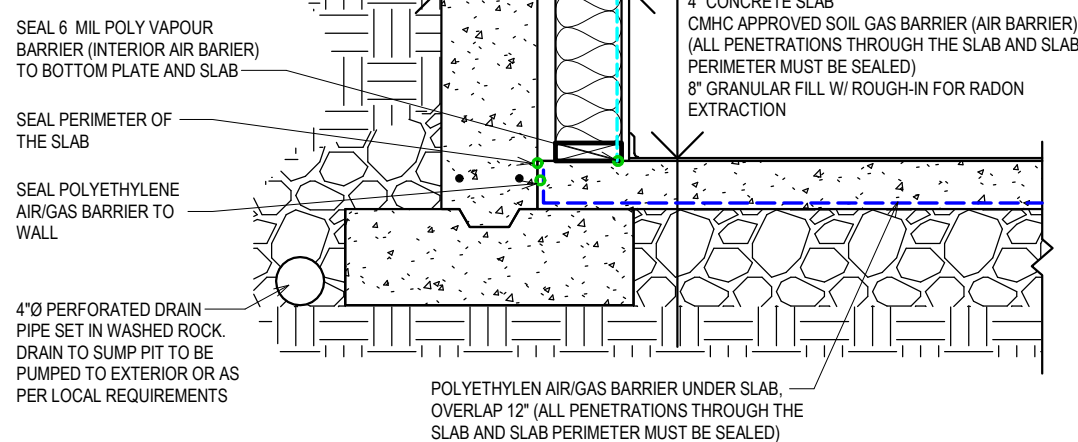


4 TOP OF FOOTING
A12 SCALE: 3/4" = 1'-0"


EXTERIOR WALL

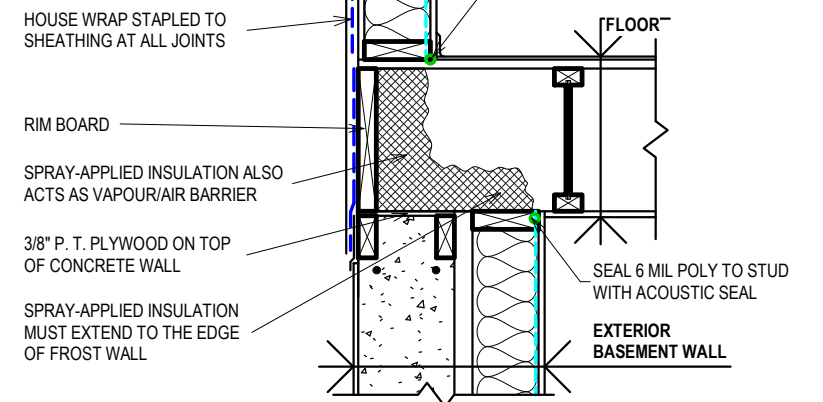


6 RIM BOARD ON CONCRETE
A12 SCALE: 3/4" = 1'-0"

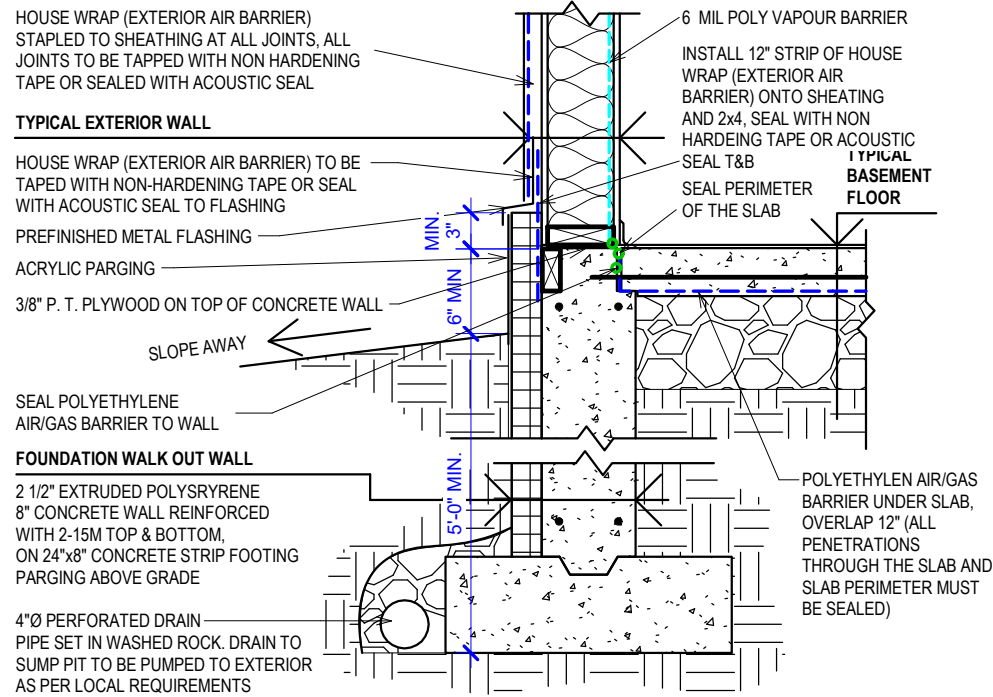


1 WALK-OUT BASEMENT
A13 SCALE: 3/4" = 1'-0"

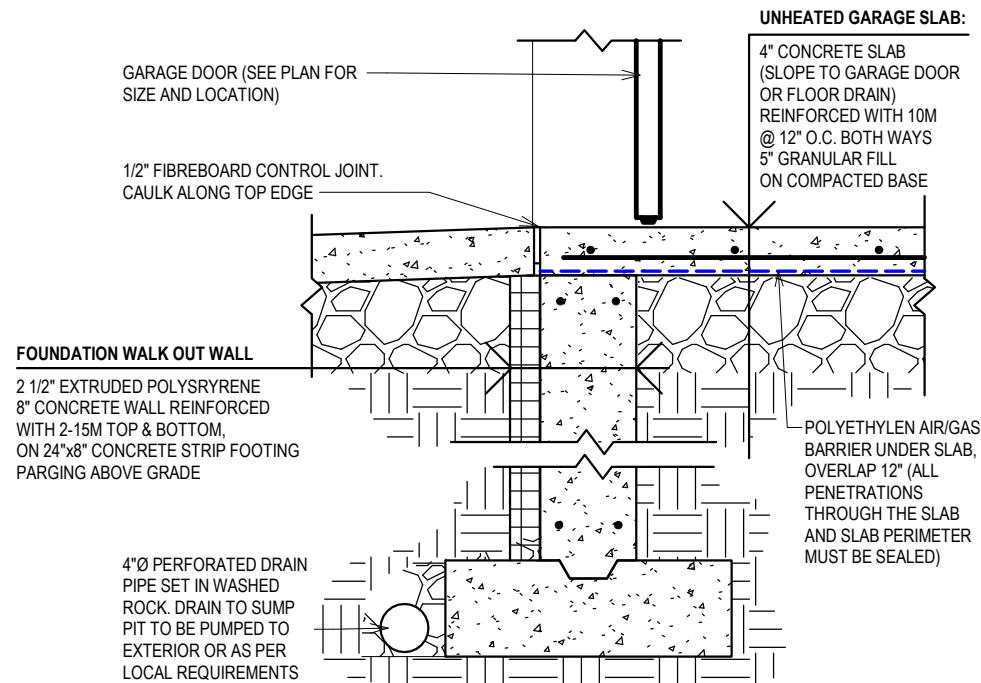


2 GARAGE DOOR
A13 SCALE: 3/4" = 1'-0"

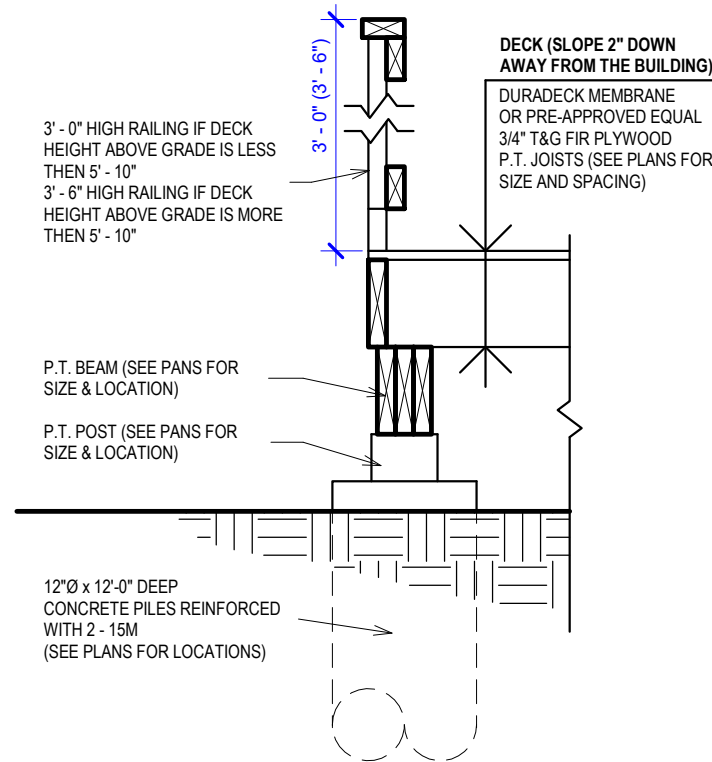


3 DECK
A13 SCALE: 3/4" = 1'-0"

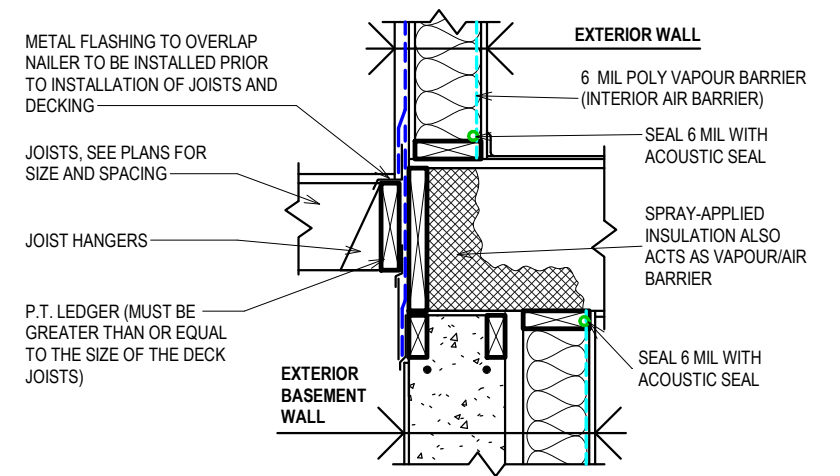


5 DECK LEDGER
A13 SCALE: 3/4" = 1'-0"

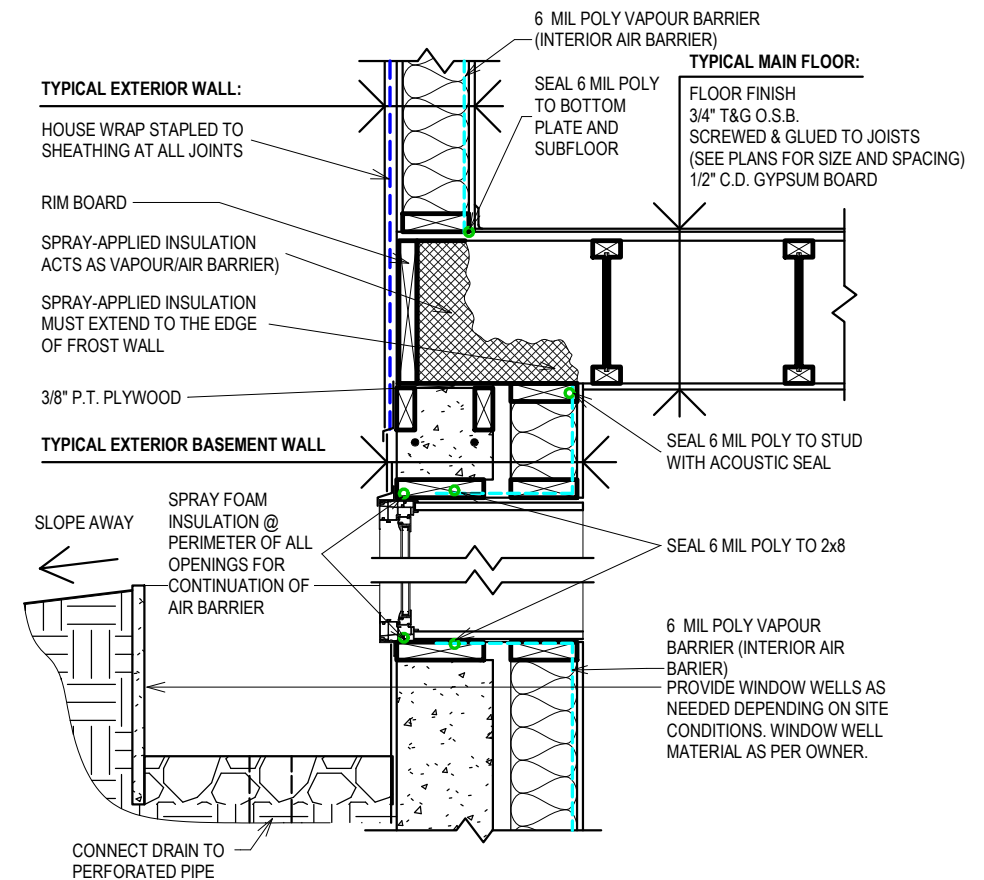


6 WINDOW WELL
A13 SCALE: 3/4" = 1'-0"

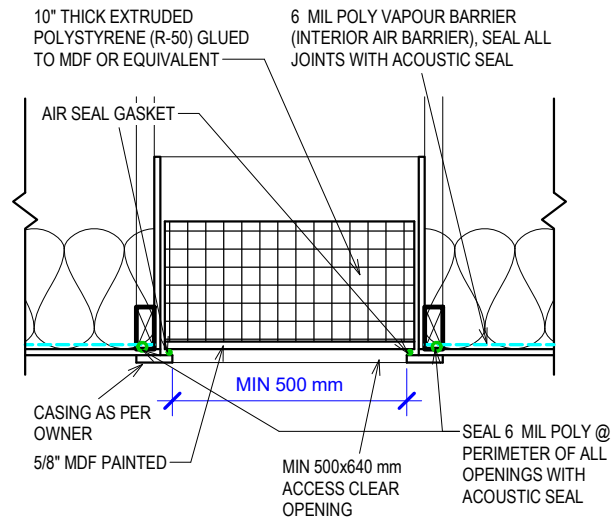




1 ATTIC ACCESS HATCH
A14 SCALE: 3/4" = 1'-0"

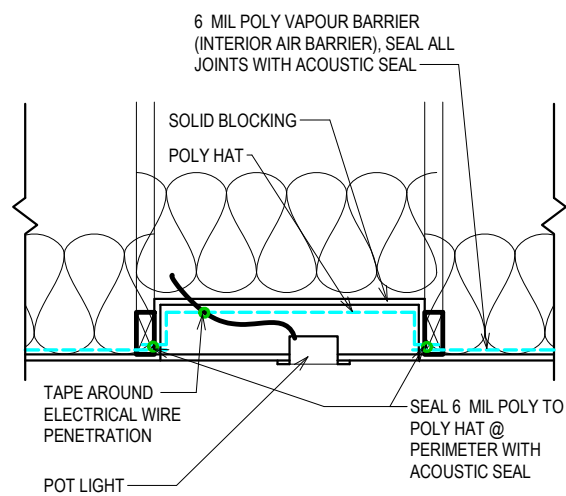

2 ATTIC POT LIGHT
A14 SCALE: 3/4" = 1'-0"

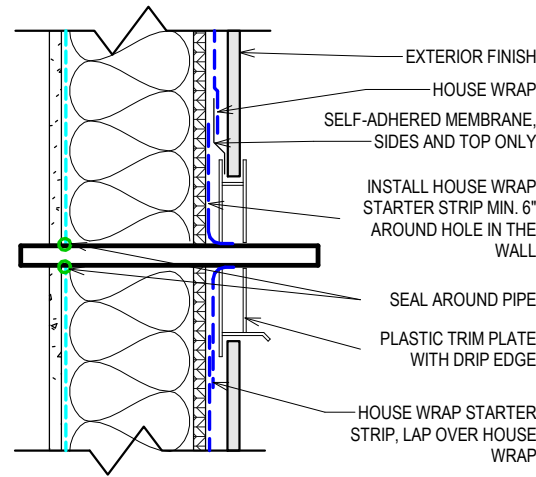


4 DETAILS - PIPE PENETRATION
A14 SCALE: 1 1/2" = 1'-0"

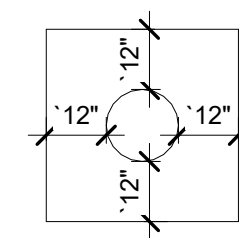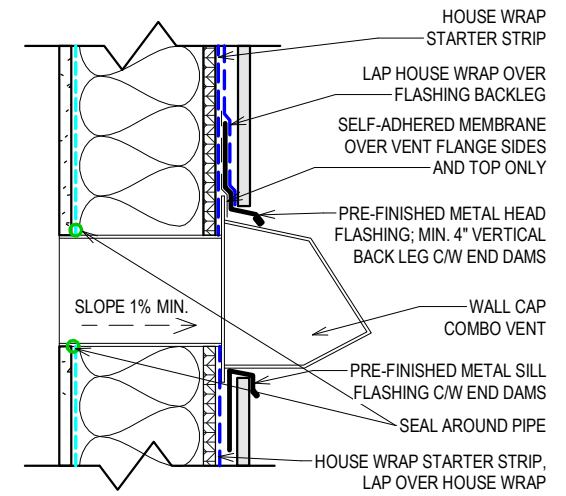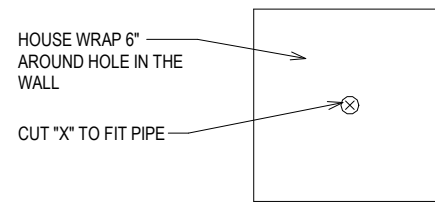


- INSTALLATION SEQUENCE:
- 1) INSTALL 1 LAYER OF WEATHER BARRIER EXTENDING 12" BEYOND ALL SIDES OF THE HOLE IN THE WALL.
 - 2) APPLY A POLYURETHANE CAULK TO BACK OF THE 2" FLANGE TOP AND SIDES ONLY. DO NOT CAULK THE BOTTOM.
 - 3) SECURE VENT HOOD PLUMB & SQUARE.
 - 4) INSTALL BOTH JAMB SEALS BEFORE HEAD SEAL; OVERLAP MOUNTING FLANGES (ADHESIVE MEMBRANE STRIPS)

5 DETAILS - VENT CAP INSTALLATION
A14 SCALE: 1 1/2" = 1'-0"

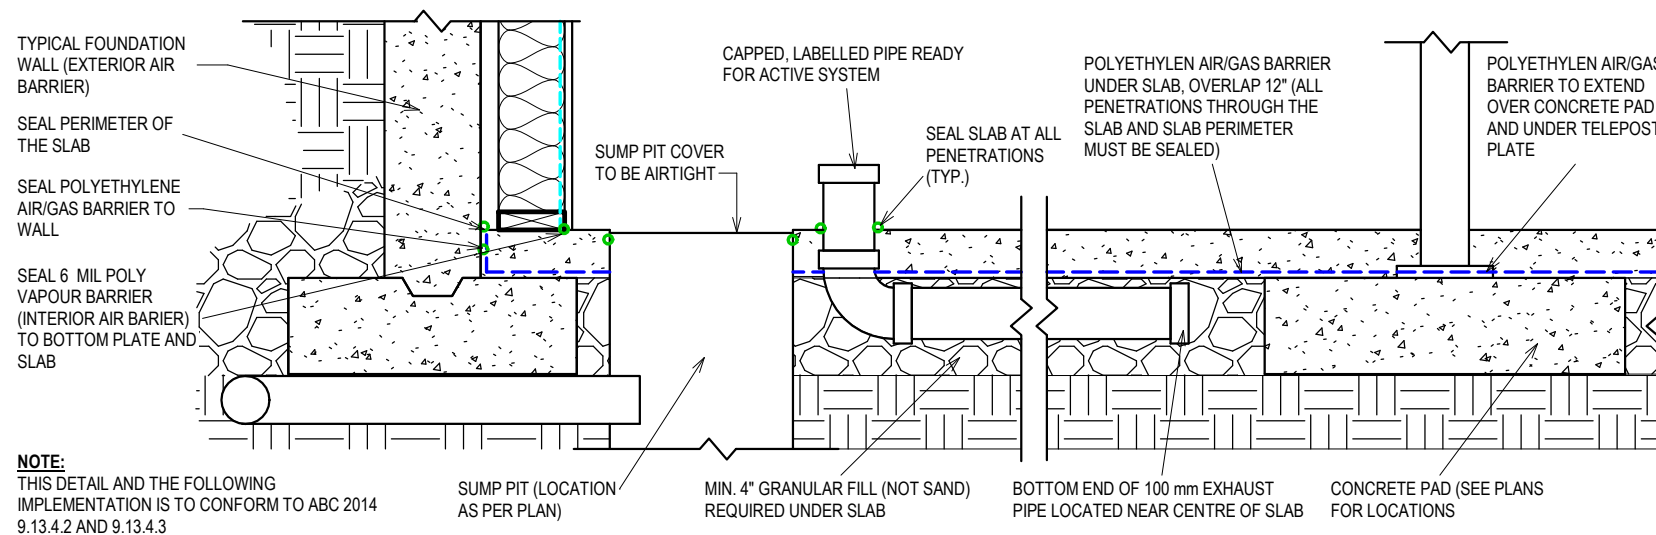

NOTE:
THIS DETAIL AND THE FOLLOWING IMPLEMENTATION IS TO CONFORM TO ABC 2014 9.13.4.2 AND 9.13.4.3


3 RADON GAS EXTRACTION ROUGH IN
A14 SCALE: 3/4" = 1'-0"

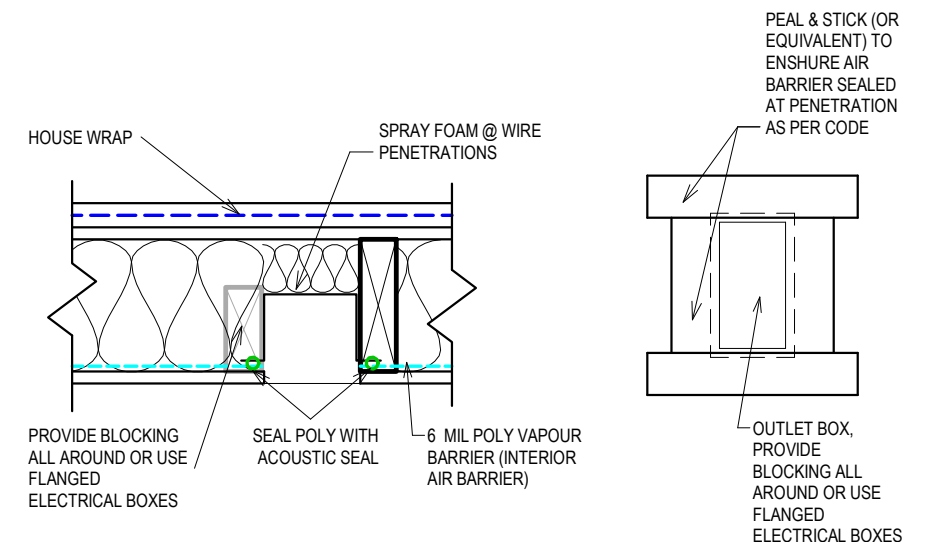

6 TYPICAL ELECTRICAL BOX
A14 SCALE: 1 1/2" = 1'-0"

TYPICAL ROOF (SEE ROOF PLAN FOR SLOPE):

ROOFING (SEE ELEVATIONS FOR MATERIAL)
C/W 6' EAVE PROTECTION
3/8" O.S.B. WITH H-CLIPS
PRE-ENGINEERED WOOD TRUSSES @ 24" O.C.
14" CELLULOSE LOOSE FILL INSULATION (R-49)
6 MIL CMHC APPROVED VAPOUR BARRIER (INTERIOR AIR BARRIER),
SEAL ALL JOINTS WITH ACOUSTIC SEAL,
1/2" C.D. GYPSUM BOARD

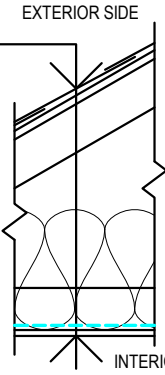

ROOF ASSEMBLY COMPONENTS:

OUTSIDE AIR FILM	0.030
PRE-ENGINEERED WOOD TRUSSES @ 24" O.C. (11%)	
W/ 3.5" LOOSE FILL CELLULOSE INSULATION (89%)	1.833
10.5" LOOSE-FILL CELLULOSE INSULATION	6.650
6 MIL CMHC APPROVED VAPOUR BARRIER	0.000
1/2" C.D. GYPSUM BOARD	0.080
INTERIOR AIR FILM	0.110
RSI OF ENTIRE ASSEMBLY	8.703
MINIMUM RSI AS PER ABC	8.67

1


A15

TYPICAL ROOF

SCALE: 3/4" = 1'-0"

TYPICAL ROOF (SEE ROOF PLAN FOR SLOPE):

ROOFING (SEE ELEVATIONS FOR MATERIAL)
C/W 6' EAVE PROTECTION
1/2" O.S.B. WITH H-CLIPS
R-22 CONTINUOUS BATT INSULATION ABOVE THE BOTTOM CHORD OF TRUSSES
PRE-ENGINEERED WOOD TRUSSES @ 24" O.C.
WITH R-12 BATT INSULATION
6 MIL CMHC APPROVED VAPOUR BARRIER (INTERIOR AIR BARRIER), SEAL ALL JOINTS WITH ACOUSTIC SEAL
1/2" C.D. GYPSUM BOARD

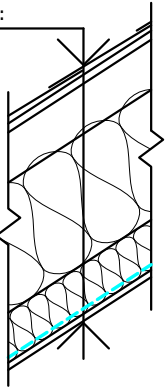

ROOF ASSEMBLY COMPONENTS:

OUTSIDE AIR FILM	0.030
R-22 BATT INSULATION	3.870
ROOF TRUSSES @ 24" O.C. (11%)	
W/R-12 BATT INSULATION (89%)	1.763
6 MIL CMHC AIR/VAPOUR BARRIER	0.000
1/2" C.D. GYPSUM BOARD	0.080
INTERIOR AIR FILM	0.110
RSI OF ENTIRE ASSEMBLY	5.853
MINIMUM RSI AS PER ABC	5.02

4


A15

ROOF (SLOPED CEILING)

SCALE: 3/4" = 1'-0"

TYPICAL EXTERIOR WALL:

ACRYLIC STUCCO
1" EXPANDED POLYSTYRENE (TYPE 2)
EXTERIOR HOUSE WRAP
3/8" O.S.B. SHEATHING
2x6 STUDS @ 16" O.C.
R-19 (R-20 COMPRESSED) BATT INSULATION
6 MIL CMHC APPROVED VAPOUR BARRIER
1/2" GYPSUM BOARD

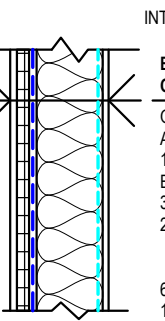

EXTERIOR WALL ASSEMBLY COMPONENTS

OUTSIDE AIR FILM	0.030
ACRYLIC STUCCO	0.000
1" EXPANDED POLYSTYRENE (TYPE 2)	0.711
EXTERIOR HOUSE WRAP	0.000
3/8" O.S.B. SHEATHING	0.093
2x6 STUDS @ 16" O.C. (23%)	
W/R-19 (R-20 COMPRESSED) BATT INSULATION (77%)	2.360
6 MIL VAPOUR BARRIER	0.000
1/2" GYPSUM BOARD	0.080
INTERIOR AIR FILM	0.120
RSI OF ENTIRE ASSEMBLY	3.394
MINIMUM RSI AS PER ABC	2.97

2


A15

TYPICAL EXTERIOR WALL

SCALE: 3/4" = 1'-0"

TYPICAL EXTERIOR WALL:

2" CULTURED STONE
EXTERIOR HOUSE WRAP
3/8" O.S.B. SHEATHING
2x6 STUDS @ 16" O.C.
R-24 BATT INSULATION
6 MIL CMHC APPROVED VAPOUR BARRIER
1/2" GYPSUM BOARD

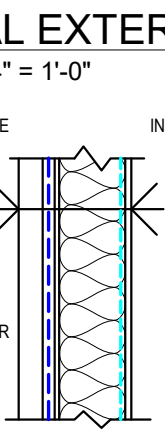

EXTERIOR WALL ASSEMBLY COMPONENTS

OUTSIDE AIR FILM	0.030
2" CULTURED STONE	0.015
EXTERIOR HOUSE WRAP	0.000
3/8" O.S.B. SHEATHING	0.093
2x6 STUDS @ 16" O.C. (23%)	
W/R-24 BATT INSULATION (77%)	2.664
6 MIL VAPOUR BARRIER	0.000
1/2" GYPSUM BOARD	0.080
INTERIOR AIR FILM	0.120
RSI OF ENTIRE ASSEMBLY	3.003
MINIMUM RSI AS PER ABC	2.97

3


A15

EXTERIOR WALL (CULTURED STONE)

SCALE: 3/4" = 1'-0"

EXTERIOR WALL RIM BOARD:

ACRYLIC STUCCO
1" EXPANDED POLYSTYRENE
EXTERIOR HOUSE WRAP
1 1/4" RIM BOARD
MIN. 2" THICK SPRAYED POLYURETHANE
FOAM INSULATION (MEDIUM DENSITY, ACTS AS VAPOUR BARRIER)

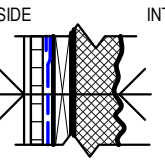

RIM BOARD ASSEMBLY COMPONENTS

OUTSIDE AIR FILM	0.030
1" EXPANDED POLYSTYRENE TYPE 2	0.711
EXTERIOR HOUSE WRAP	0.000
1 1/4" RIM BOARD	0.272
I-JOIST @ 16 O.C. (9%)	
W/ 2" THICK SPRAYED POLYURETHANE FOAM (MEDIUM DENSITY) (91%)	2.142
INTERIOR AIR FILM	0.120
RSI OF ENTIRE ASSEMBLY	3.275
MINIMUM RSI AS PER ABC	2.97

5


A15

TYPICAL RIM BOARD

SCALE: 3/4" = 1'-0"

TYPICAL EXTERIOR BASEMENT WALL:

8" CONCRETE WALL REINFORCED WITH 2-15M TOP & BOTTOM, ON 24"x8" CONCRETE STRIP FOOTING PARGING ABOVE GRADE DAMPPROOFING BELOW GRADE
1 1/2" AIR SPACE
2x6 STUDS @ 24" O.C.
R-20 BATT INSULATION
6 MIL CMHC APPROVED VAPOUR BARRIER
1/2" GYPSUM BOARD
(POSSIBLE DAMPPROOFING ON INSIDE FACE OF CONCRETE IF REQUIRED BY MUNICIPAL REGULATIONS)

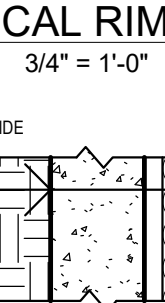

EXTERIOR BASEMENT WALL ASSEMBLY COMPONENTS

8" CONCRETE WALL	0.081
2x6 STUDS @ 24" O.C. (13%)	
W/R-20 BATT INSULATION (87%)	2.806
6 MIL VAPOUR BARRIER	0.000
1/2" GYPSUM BOARD	0.080
INTERIOR AIR FILM	0.120
RSI OF ENTIRE ASSEMBLY	3.087
MINIMUM RSI AS PER ABC	2.980

6


A15

TYPICAL BASEMENT WALL

SCALE: 3/4" = 1'-0"

HOUSE/GARAGE WALL:

1/2" DRYWALL
3/8" O.S.B. SHEATHING
2x6 STUDS @ 16" O.C.
R-22 BATT INSULATION
6 MIL CMHC APPROVED VAPOUR BARRIER
1/2" GYPSUM BOARD

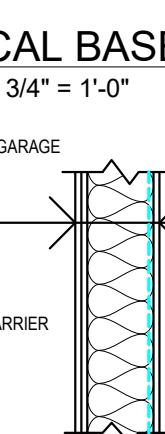

HOUSE/GARAGE WALL ASSEMBLY COMPONENTS

OUTSIDE AIR FILM	0.030
1/2" DRYWALL	0.080
3/8" O.S.B. SHEATHING	0.093
2x6 STUDS @ 16" O.C. (23%)	
W/R-22 BATT INSULATION (77%)	2.594
6 MIL VAPOUR BARRIER	0.000
1/2" GYPSUM BOARD	0.080
INTERIOR AIR FILM	0.120
RSI OF ENTIRE ASSEMBLY	2.952
MINIMUM RSI AS PER ABC	2.81

7


A15

HOUSE/GARAGE WALL

SCALE: 3/4" = 1'-0"

FLOOR ABOVE GARAGE:

FLOOR FINISH
3/4" T&G O.S.B.
SCREWED & GLUED TO I-JOISTS @ 16" O.C.
WITH R-12 BATT INSULATION
2x6 FRAMING @ 16" O.C.
WITH R-22 BATT INSULATION
1/2" GYPSUM BOARD

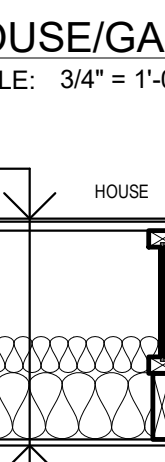

FLOOR ABOVE GARAGE ASSEMBLY COMPONENTS:

INTERIOR AIR FILM	0.160
I-JOIST @ 16" O.C. (9%)	
W/ R-12 BATT INSULATION (91%)	1.817
2x6 @ 16 O.C. (13%)	
W/ R-22 BATT INSULATION (87%)	2.991
1/2" GYPSUM BOARD	0.120
OUTSIDE AIR FILM	0.030
RSI OF ENTIRE ASSEMBLY	5.118
MINIMUM RSI AS PER ABC	5.02

8


A15

FLOOR ABOVE GARAGE

SCALE: 3/4" = 1'-0"

EXTERIOR LINTEL:

ACRYLIC STUCCO
1" EXPANDED POLYSTYRENE (TYPE 2)
EXTERIOR HOUSE WRAP
3/8" O.S.B. SHEATHING
2-2x10 TO MAXIMUM SPAN 6'-0"
2" EXTRUDED POLYSTYRENE
1/2" GYPSUM BOARD (EXTRA LAYER)
6 MIL CMHC APPROVED VAPOUR BARRIER
1/2" GYPSUM BOARD

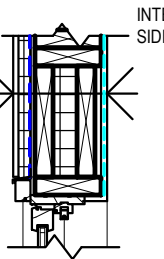

HEADER ASSEMBLY COMPONENTS

OUTSIDE AIR FILM	0.030
1" EXPANDED POLYSTYRENE	0.711
EXTERIOR HOUSE WRAP	0.000
3/8" O.S.B. SHEATHING	0.093
1 1/2" LUMBER (2x10 PLATE)	0.324
2" EXTRUDED POLYSTYRENE	1.707
1 1/2" LUMBER (2x10 PLATE)	0.324
1/2" GYPSUM BOARD	0.080
6 MIL VAPOUR BARRIER	0.000
1/2" GYPSUM BOARD	0.080
INTERIOR AIR FILM	0.120
RSI OF ENTIRE ASSEMBLY	3.439
MINIMUM RSI AS PER ABC	2.97

10

A15

TYPICAL HEADER

SCALE: 3/4" = 1'-0"



easy to read house plans
LikeHomeDesign.com Inc.
780.757.6543
stock plans - custom house - multi-unit
additions - commercial - industrial

LIKEHOMEDESIGN.COM INC. ASSUMES NO LIABILITY FOR ERRORS OR OMISSIONS THAT MAY AFFECT CONSTRUCTION. IT IS THE RESPONSIBILITY OF THE GENERAL CONTRACTOR / BUILDER TO CHECK AND VERIFY ALL SIZES, DIMENSIONS AND COSTRUCTION DETAILS PRIOR TO ANY CONSTRUCTION. ALL DISCREPANCIES TO BE REPORTED TO LIKEHOMEDESIGN.COM INC. FOR CLARIFICATION PRIOR TO CONSTRUCTION. DO NOT SCALE DRAWINGS. VARIATIONS AND MODIFICATIONS TO WORK SHOWN ON THESE DRAWINGS SHALL NOT BE CARRIED OUT WITHOUT WRITTEN PERMISSION FROM LIKEHOMEDESIGN.COM INC.

LIKEHOMEDESIGN.COM INC. WAIVES ALL REPONSIBILITY REGARDING ANY STRUCTURAL ENGINEERING AND ONSITE CONDITIONS SUCH AS SOIL BEARING CAPACITY, DEPTH OF FROST LINE, WATER TABLES. ALL ENGINEERING AND ENGINEERS STAMP TO BE THE SOLE RESPONSIBILITY OF BUILDER AND/OR OWNER. THESE PLANS, DESIGNS, AND DETAILS ARE THE PROPERTY OF LIKEHOMEDESIG.COM INC. AND MAY NOT BE REPRODUCED OR USED BY ANYONE, EITHER IN TOTAL OR IN PART, WITHOUT WRITTEN CONSENT FROM LIKEHOMEDESIG.COM INC.

CLIENT/BUILDER
BUILDER PROJECT #
BUILDER PROJECT NAME:


ADDRESS
LEGAL

**ABEL & CHRISTINE
RESIDENCE**


PROJECT # 855
STATUS ISSUED FOR PERMITS
DATE MARCH 28, 2022
DRAWN BY OP
CHECKED BY IT
SCALE 3/4" = 1'-0"

DETAILED RSI SECTIONS


A15

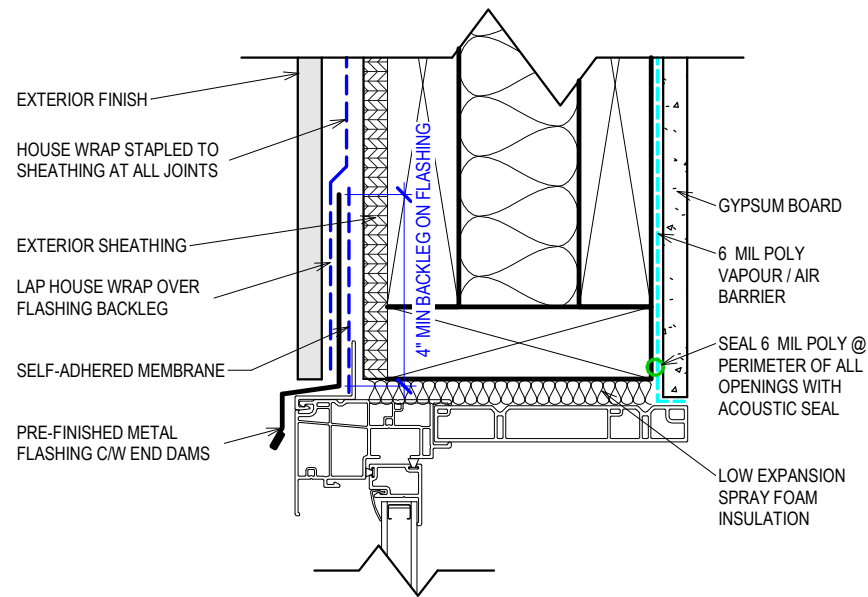


1 WINDOW HEAD
A16 SCALE: 3" = 1'-0"

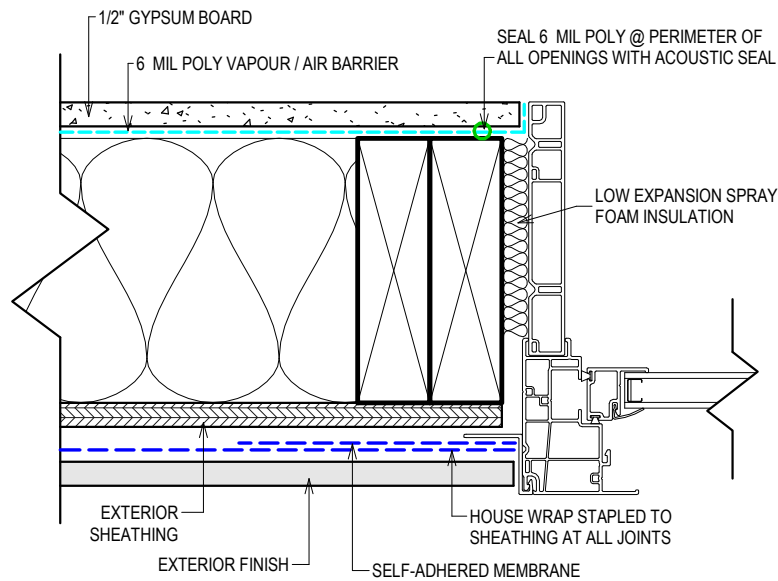

2 WINDOW JAMB
A16 SCALE: 3" = 1'-0"

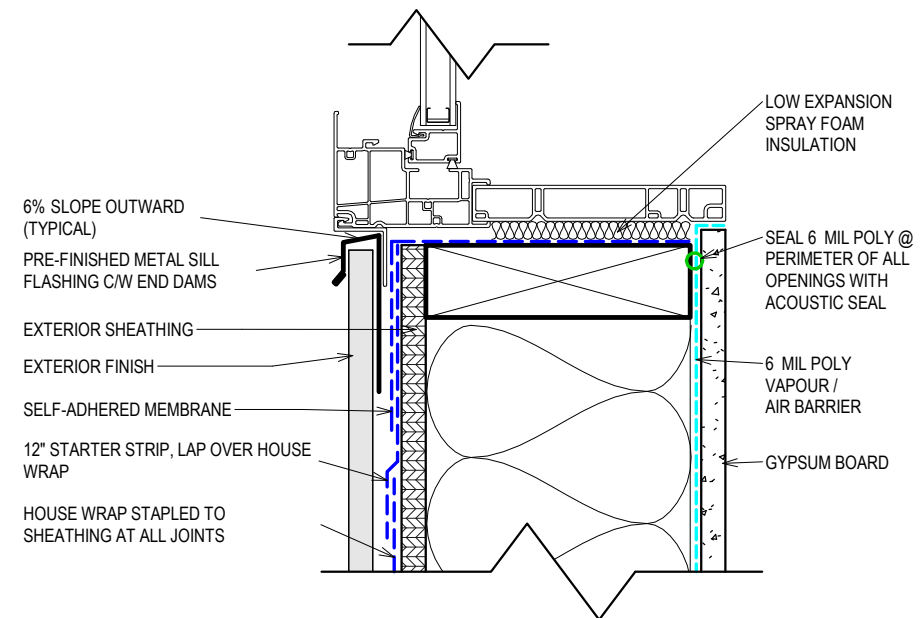

3 WINDOW SILL
A16 SCALE: 3" = 1'-0"

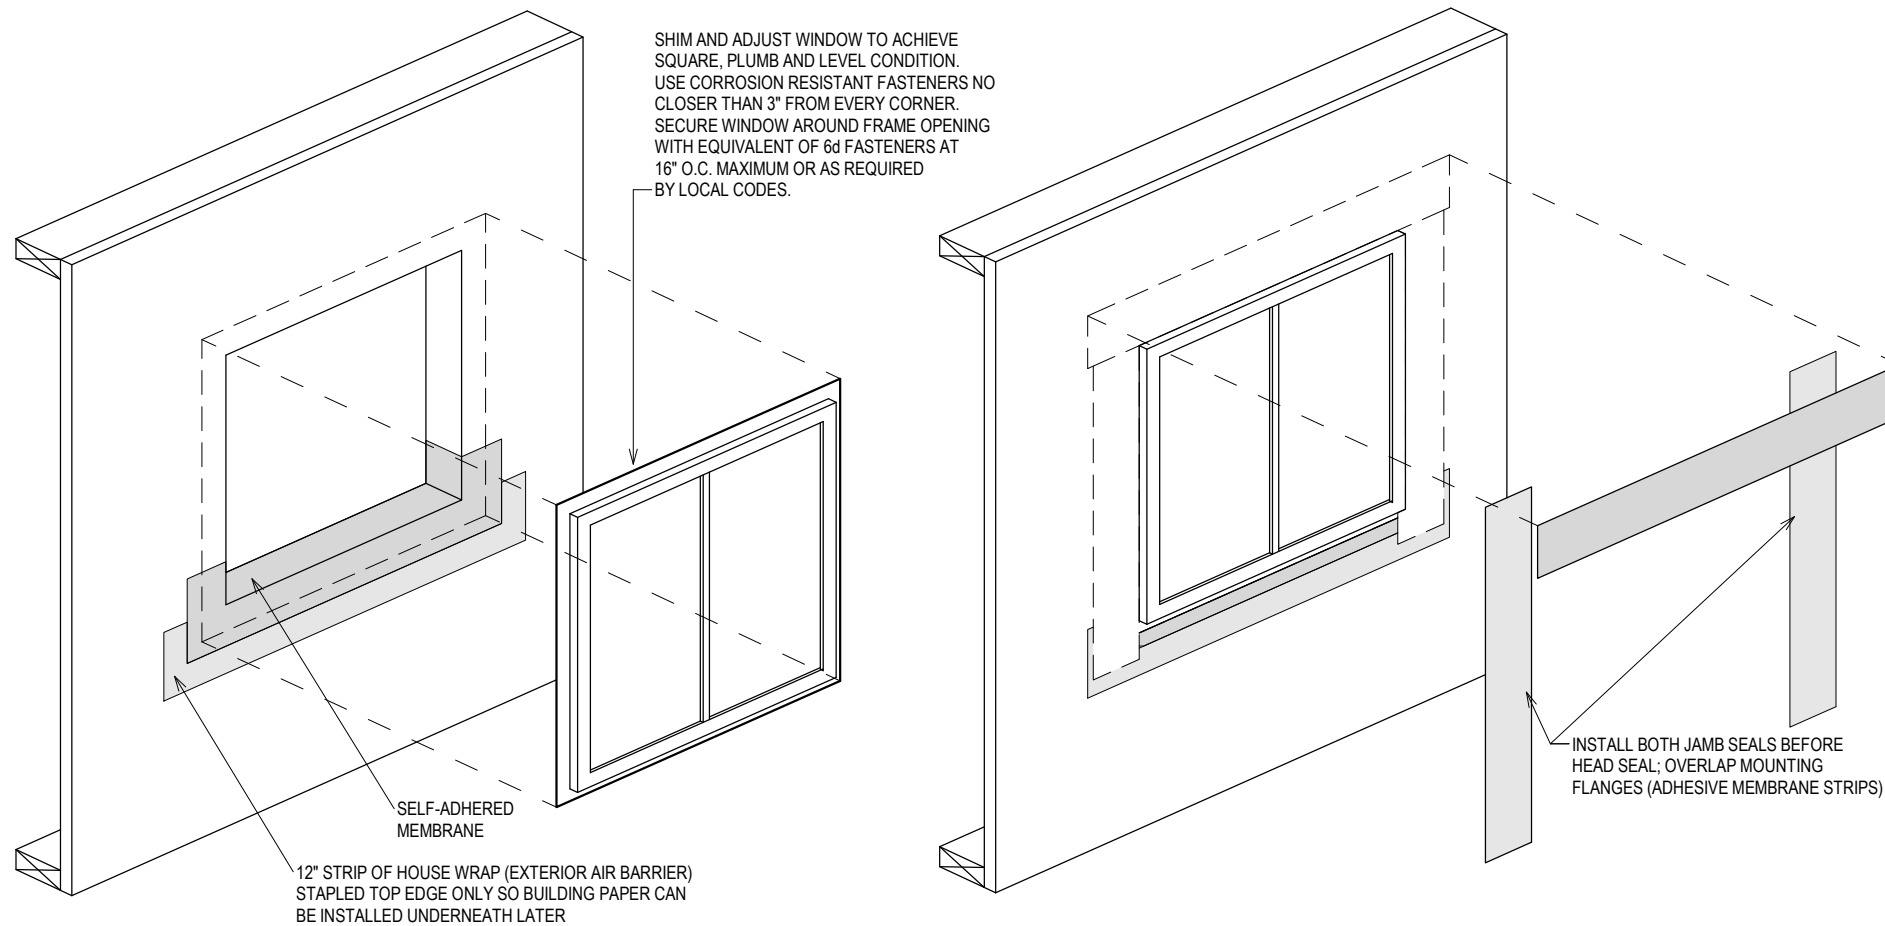

4 TYPICAL WINDOW INSTALLATION
A16 SCALE: 1/2" = 1'-0"



easy to read house plans

LikeHomeDesign.com Inc.

780.757.6543

stock plans - custom house - multi-unit
additions - commercial - industrial

LIKEHOMEDESIGN.COM INC. ASSUMES NO LIABILITY FOR ERRORS OR OMISSIONS THAT MAY AFFECT CONSTRUCTION. IT IS THE RESPONSIBILITY OF THE GENERAL CONTRACTOR / BUILDER TO CHECK AND VERIFY ALL SIZES, DIMENSIONS AND CONSTRUCTION DETAILS PRIOR TO ANY CONSTRUCTION. ALL DISCREPANCIES TO BE REPORTED TO LIKEHOMEDESIGN.COM INC. FOR CLARIFICATION PRIOR TO CONSTRUCTION. DO NOT SCALE DRAWINGS. VARIATIONS AND MODIFICATIONS TO WORK SHOWN ON THESE DRAWINGS SHALL NOT BE CARRIED OUT WITHOUT WRITTEN PERMISSION FROM LIKEHOMEDESIGN.COM INC.

LIKEHOMEDESIGN.COM INC. WAIVES ALL RESPONSIBILITY REGARDING ANY STRUCTURAL ENGINEERING AND ON-SITE CONDITIONS SUCH AS SOIL BEARING CAPACITY, DEPTH OF FROST LINE, WATER TABLES. ALL ENGINEERING AND ENGINEERS STAMP TO BE THE SOLE RESPONSIBILITY OF BUILDER AND/OR OWNER. THESE PLANS, DESIGNS, AND DETAILS ARE THE PROPERTY OF LIKEHOMEDESIGN.COM INC. AND MAY NOT BE REPRODUCED OR USED BY ANYONE, EITHER IN TOTAL OR IN PART, WITHOUT WRITTEN CONSENT FROM LIKEHOMEDESIGN.COM INC.

CLIENT/BUILDER

BUILDER PROJECT #

BUILDER PROJECT NAME:

ADDRESS

LEGAL

**ABEL & CHRISTINE
RESIDENCE**

PROJECT # 855

STATUS ISSUED FOR PERMITS

DATE MARCH 28, 2022


DRAWN BY OP

CHECKED BY IT


SCALE As indicated

WINDOW DETAILS


A16

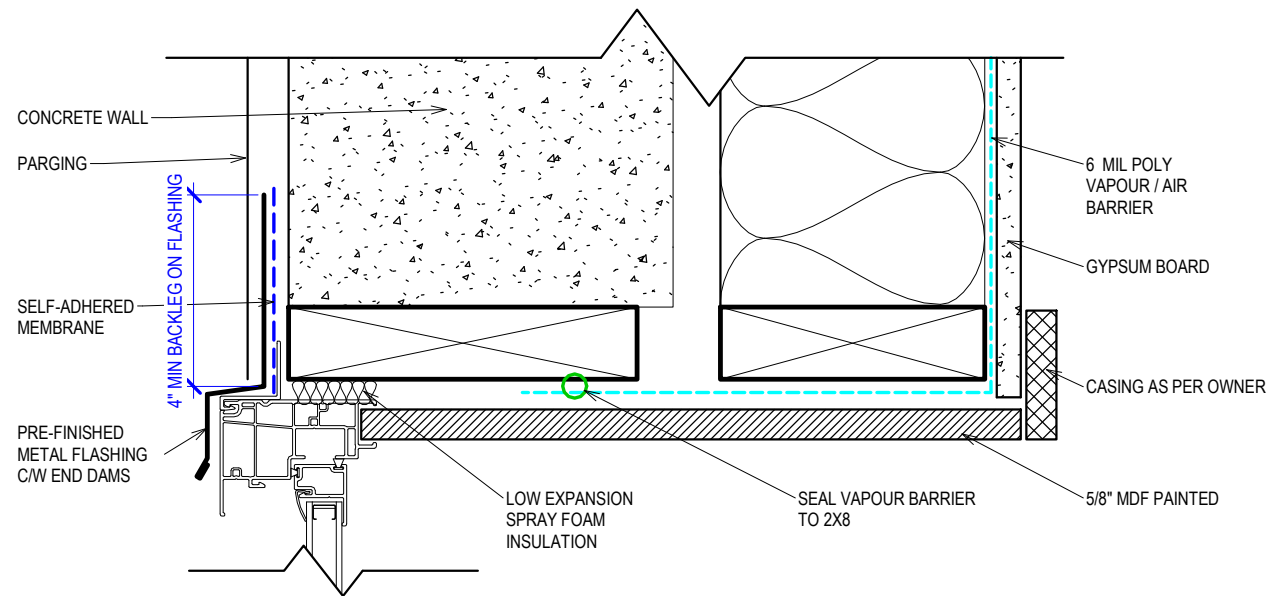


1
A17 **WINDOW HEAD (CONCRETE)**
SCALE: 3" = 1'-0"

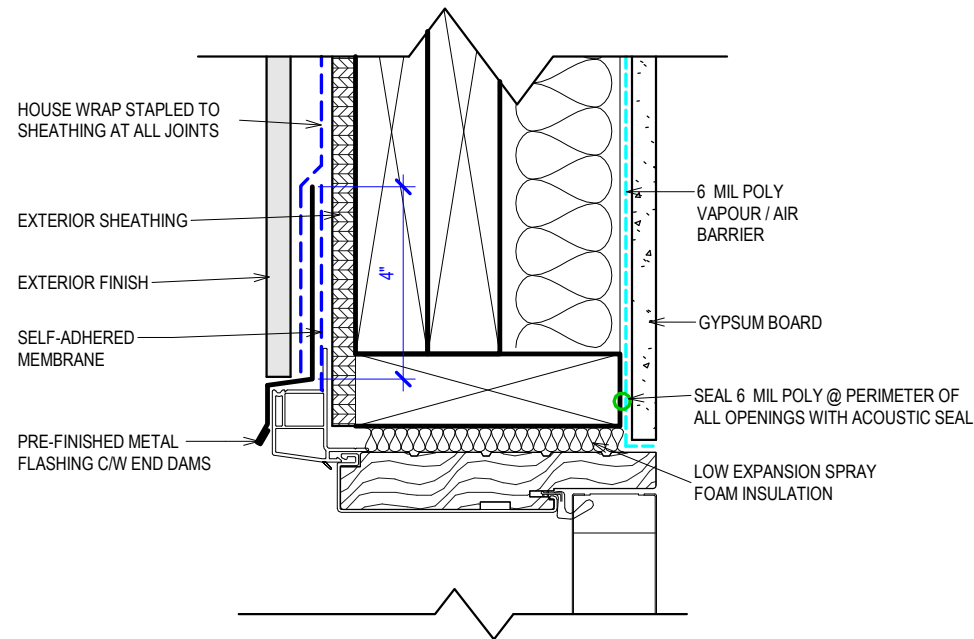


3
A17 **DOOR HEAD**
SCALE: 3" = 1'-0"

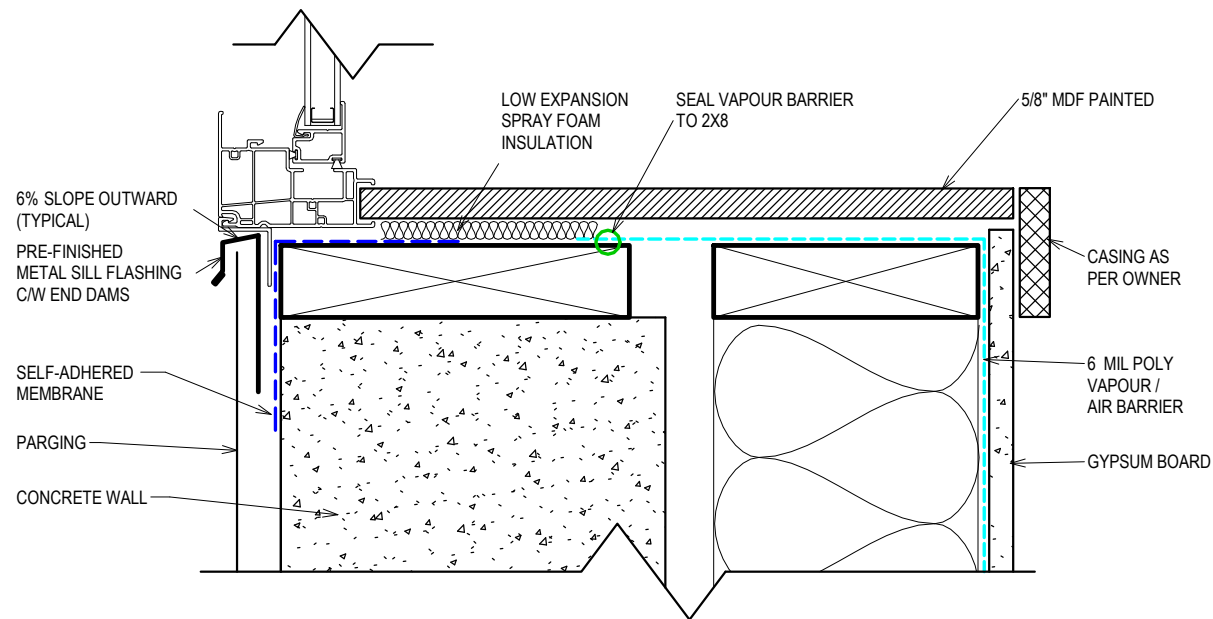

2
A17 **WINDOW SILL (CONCRETE)**
SCALE: 3" = 1'-0"

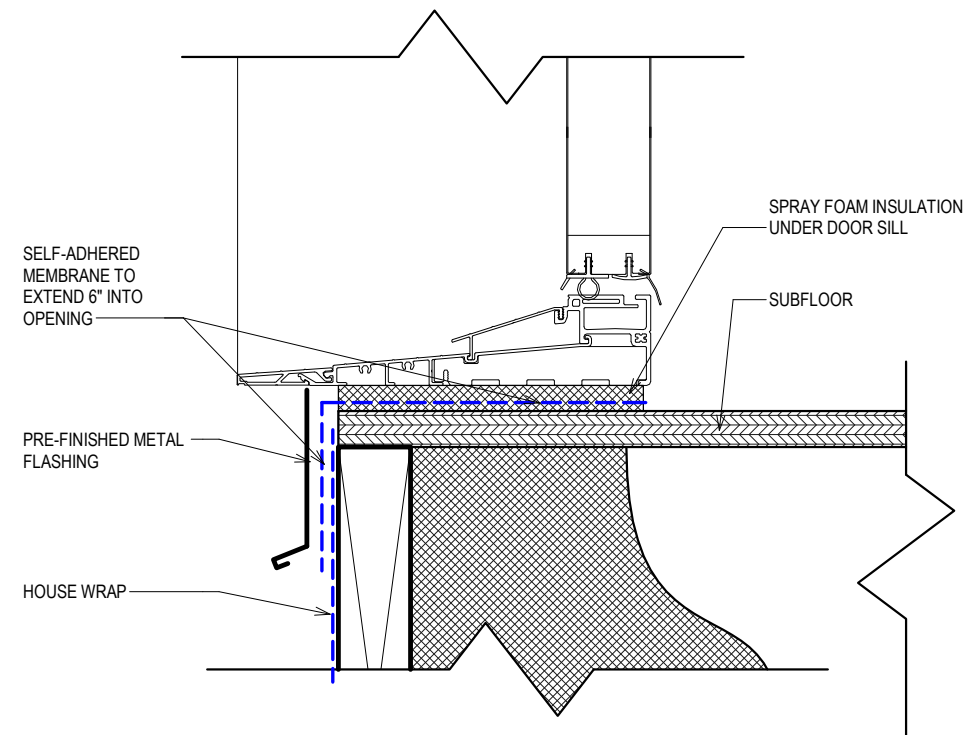

4
A17 **DOOR SILL**
SCALE: 3" = 1'-0"

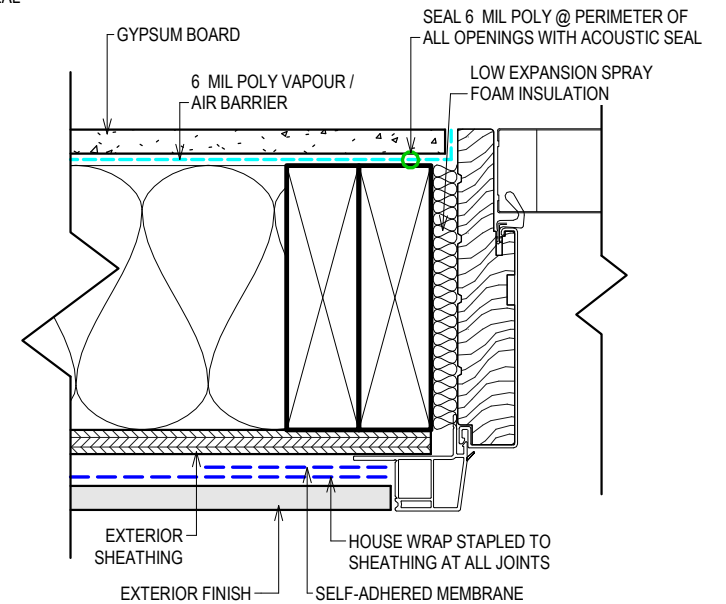

5
A17 **DOOR JAMB**
SCALE: 3" = 1'-0"